

REVISIONS	
DESCRIPTION	DATE
OWNER CHANGES	2/16/15
SITE SUBMITTAL	3/11/15

OWNER
SELECT DEVELOPMENT & CONTRACTING, LLC
 660 EAST FRANKLIN ROAD, MERIDIAN, ID 83642

PROJECT
Boardwalks Fun Center
 CROWN POINT DEVELOPMENT
 PARKER, CO

COPYRIGHT
 2015

Peter H. Rockwell, Architect
 Architecture • Planning
 595 S Americana Boulevard Boise, Idaho 83702
 (208) 345-0566 (208) 345-1718 Fax (208) 387-0889
 office@pgrboise.com




SITE PHOTOMETRIC PLAN
 NORTH SCALE 1" = 40'-0"

LIGHTING FIXTURE SCHEDULE-14-100					
TYPE	DESCRIPTION	MTG.	LAMPS	MFG. & CATALOG NUMBER	NOTES
CL1	ATTRACTION AREA CANOPY LIGHT, SEALED, FLUORESCENT	CANOPY MOUNTED	(2) 32W T8	LITHONIA NO. VRI-2-32	
PL1A	EXTERIOR POLE FIXTURE, WITH TYPE 3 DISTRIBUTION, 1-HEAD PER POLE 25FT POLE, 2.5FT POLE BASE	POLE MOUNTED	(1) LED 31,000 LUMEN 315-WATT	McGRAW-EDISON NO. GLEON-AE-06-LED-E1-T3-BZ-2L POLE:	
PL1B	EXTERIOR POLE FIXTURE, WITH TYPE 4 DISTRIBUTION, 1-HEAD PER POLE 25FT POLE, 2.5FT POLE BASE	POLE MOUNTED	(1) LED 31,000 LUMEN 315-WATT	McGRAW-EDISON NO. GLEON-AE-06-LED-E1-T4FT-BZ-2L POLE:	
PL2	EXTERIOR POLE FIXTURE, WITH TYPE 4 DISTRIBUTION, 2-HEADS PER POLE 25FT POLE, 2.5FT POLE BASE	POLE MOUNTED	(2) LED 31,000 LUMEN 315-WATT	McGRAW-EDISON NO. GLEON-AE-06-LED-E1-T4FT-BZ-2L POLE:	
PL3	EXTERIOR POLE FIXTURE, WITH TYPE 5 DISTRIBUTION, 3-HEADS PER POLE 25FT POLE, 2.5FT POLE BASE	POLE MOUNTED	(3) LED 31,000 LUMEN 315-WATT	McGRAW-EDISON NO. GLEON-AE-06-LED-E1-T4FT-BZ-2L POLE:	
PL4	EXTERIOR POLE FIXTURE, WITH TYPE 6 DISTRIBUTION, 4-HEADS PER POLE 25FT POLE, 2.5FT POLE BASE	POLE MOUNTED	(4) LED 31,000 LUMEN 315-WATT	McGRAW-EDISON NO. GLEON-AE-06-LED-E1-T4FT-BZ-2L POLE:	
PL12A	ATTRACTION AREA, LED, EXTERIOR POLE FIXTURE, WITH TYPE 3 DISTRIBUTION, 1-HEAD PER POLE 12FT POLE, FLUSH POLE BASE	POLE MOUNTED	LED 8720 LUMEN 4000K	ANP LIGHTING NO. BVF1801-P078LD4-D-T3-40K	
PL12B	ATTRACTION AREA, LED, EXTERIOR POLE FIXTURE, WITH TYPE 5 DISTRIBUTION, 1-HEAD PER POLE 12FT POLE, FLUSH POLE BASE	POLE MOUNTED	LED 8720 LUMEN 4000K	ANP LIGHTING NO. BVF1801-P078LD4-D-T5-40K	
WL36	WALK WAY LIGHTING ON 36" STAND LED, WET LOCATION, LOW-VOLTAGE	PEDISTAL MOUNTED 36" AFG	(1) 150W METAL HALIDE	FXLUMINAIRE NO. NP-6LED-LS-BZ	
WP1	EXTERIOR BUILDING MOUNTED FIXTURE, FORWARD THROW	WALL MOUNTED	(1) 150W METAL HALIDE	LITHONIA NO. WSR-150M-FT-TB-LPI-ODBT	
WP2	EXTERIOR BUILDING MOUNTED FIXTURE, FORWARD THROW	WALL MOUNTED	(1) 70W METAL HALIDE	LITHONIA NO. WSR-70M-FT-TB-LPI-ODBT	

SITE PHOTOMETRIC PLAN FIXTURE SCHEDULE
 SCALE NONE

STATISTICS						
Description	Symbol	Avg	Max	Min	Max/Min	Avg/Min
Attraction Area	+	6.9 fc	20.3 fc	0.0 fc	N/A	N/A
Parking Lot	+	3.3 fc	12.1 fc	0.4 fc	30.3:1	6.3:1

SITE PHOTOMETRIC PLAN STATISTICS
 SCALE NONE

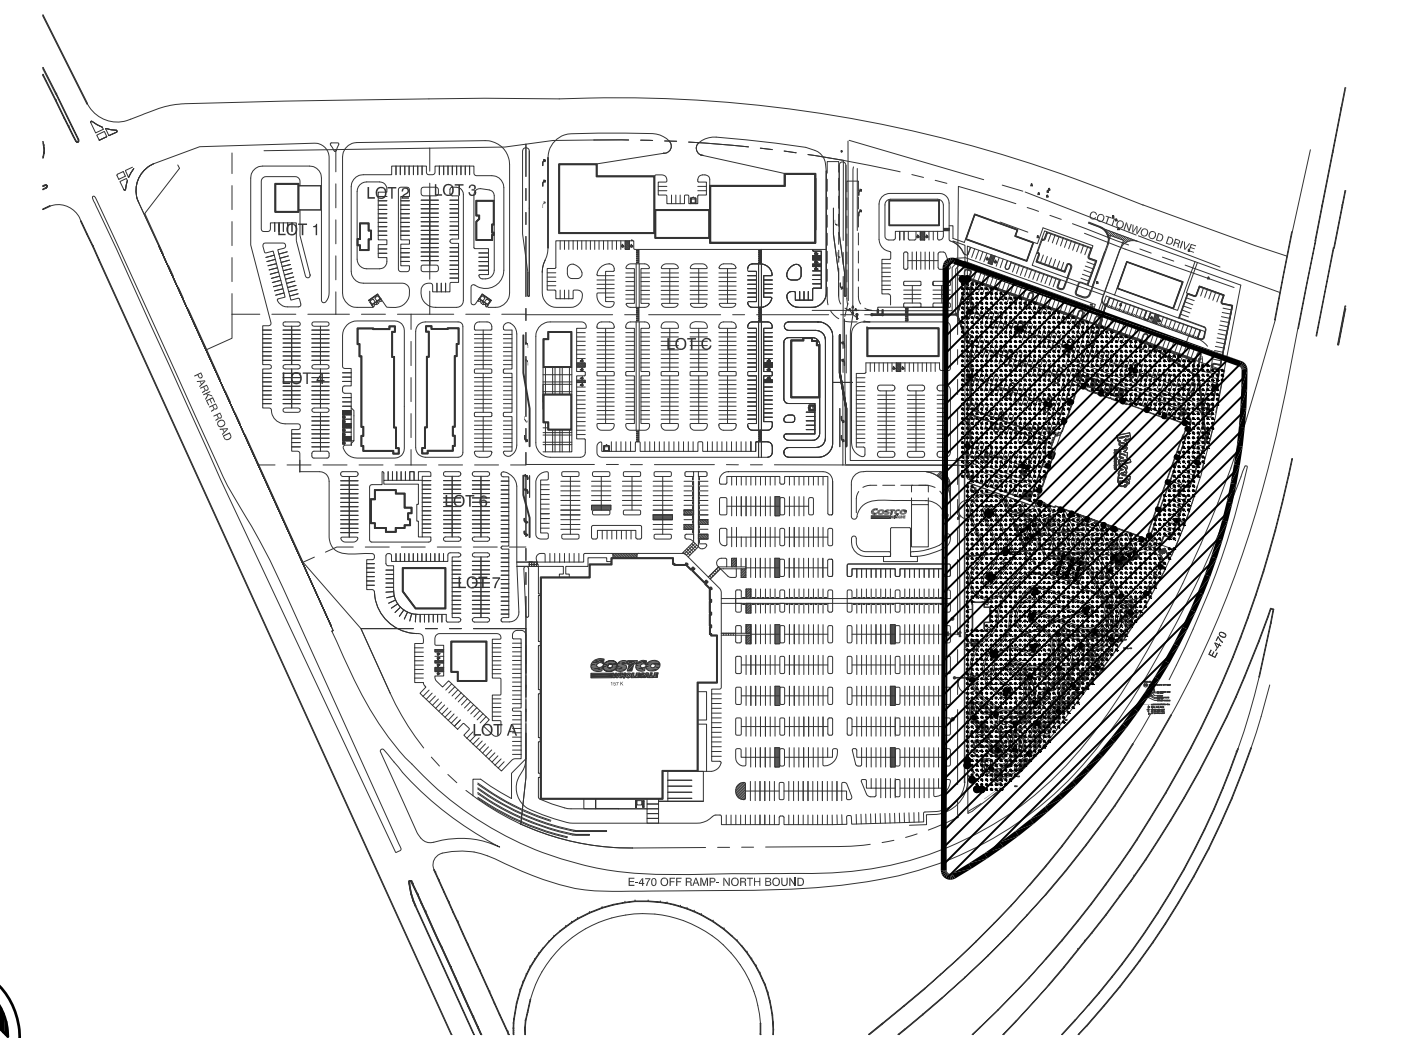

KEY
 NORTH SCALE
PLAN
 NTS

SHEET DATA	
DRAWN BY:	TF
CHECKED BY:	KL
SCALE:	AS NOTED
DATE:	3/06/15
PROJECT #:	14100
SHEET NUMBER	

E1.1