


KEYNOTES - SANITARY

15.200	3/4" GREASE RECOVERY LINE DOWN WALL TO FRYERS. COORDINATE CONNECTION TYPE WITH MANUFACTURER'S RECOMMENDATIONS.
15.201	3/4" GREASE RECOVERY LINE ABOVE CEILING.
15.202	ROUTE 1" CONDENSATE FROM COOLER DN TO TRENCH DRAIN WITH AIR GAP PER LOCAL AHJ.
15.204	3/4" GREASE RECOVERY LINE SLOPE 1/8" PER FT TOWARD GRT. PROVIDE INSULATION ON ALL INTERIOR AND EXTERIOR PIPING USE MINIMUM NUMBER OF BENDS AS POSSIBLE.
15.205	ROUTE FULL SIZE DRAIN FROM DRINK DISPENSER AND ICE MAKERS AT BEVERAGE BAR TO FS WITH CODE REQUIRED AIR GAP PER LOCAL AHJ.
15.206	PROVIDE HEAT TAPE ON CONDENSATE LINE IN WALK IN FREEZER. ROUTE HIGH AS POSSIBLE.
15.213	ROUTE FULL SIZE DRAIN FROM DRINK DISPENSER AND ICE MAKER TO FS WITH AIR GAP PER LOCAL CODE & AHJ.
15.400	REFER TO CIVIL FOR CONTINUATION. MAINTAIN A MINIMUM 30" COVER.
15.401	REFER TO CIVIL FOR CONTINUATION. MAINTAIN A MINIMUM 24" COVER.
15.402	PROVIDE INDIRECT DRAIN FROM SINK TO FS.
15.403	OVERFLOW STORM PIPE DOWN INSIDE WALL. LOCATE BOTTOM OF DOWNSPOUT 18" ABOVE GRADE.
15.404	REFER TO CIVIL FOR CONTINUATION OF STORM PIPING. MAINTAIN A MINIMUM 30" COVER.

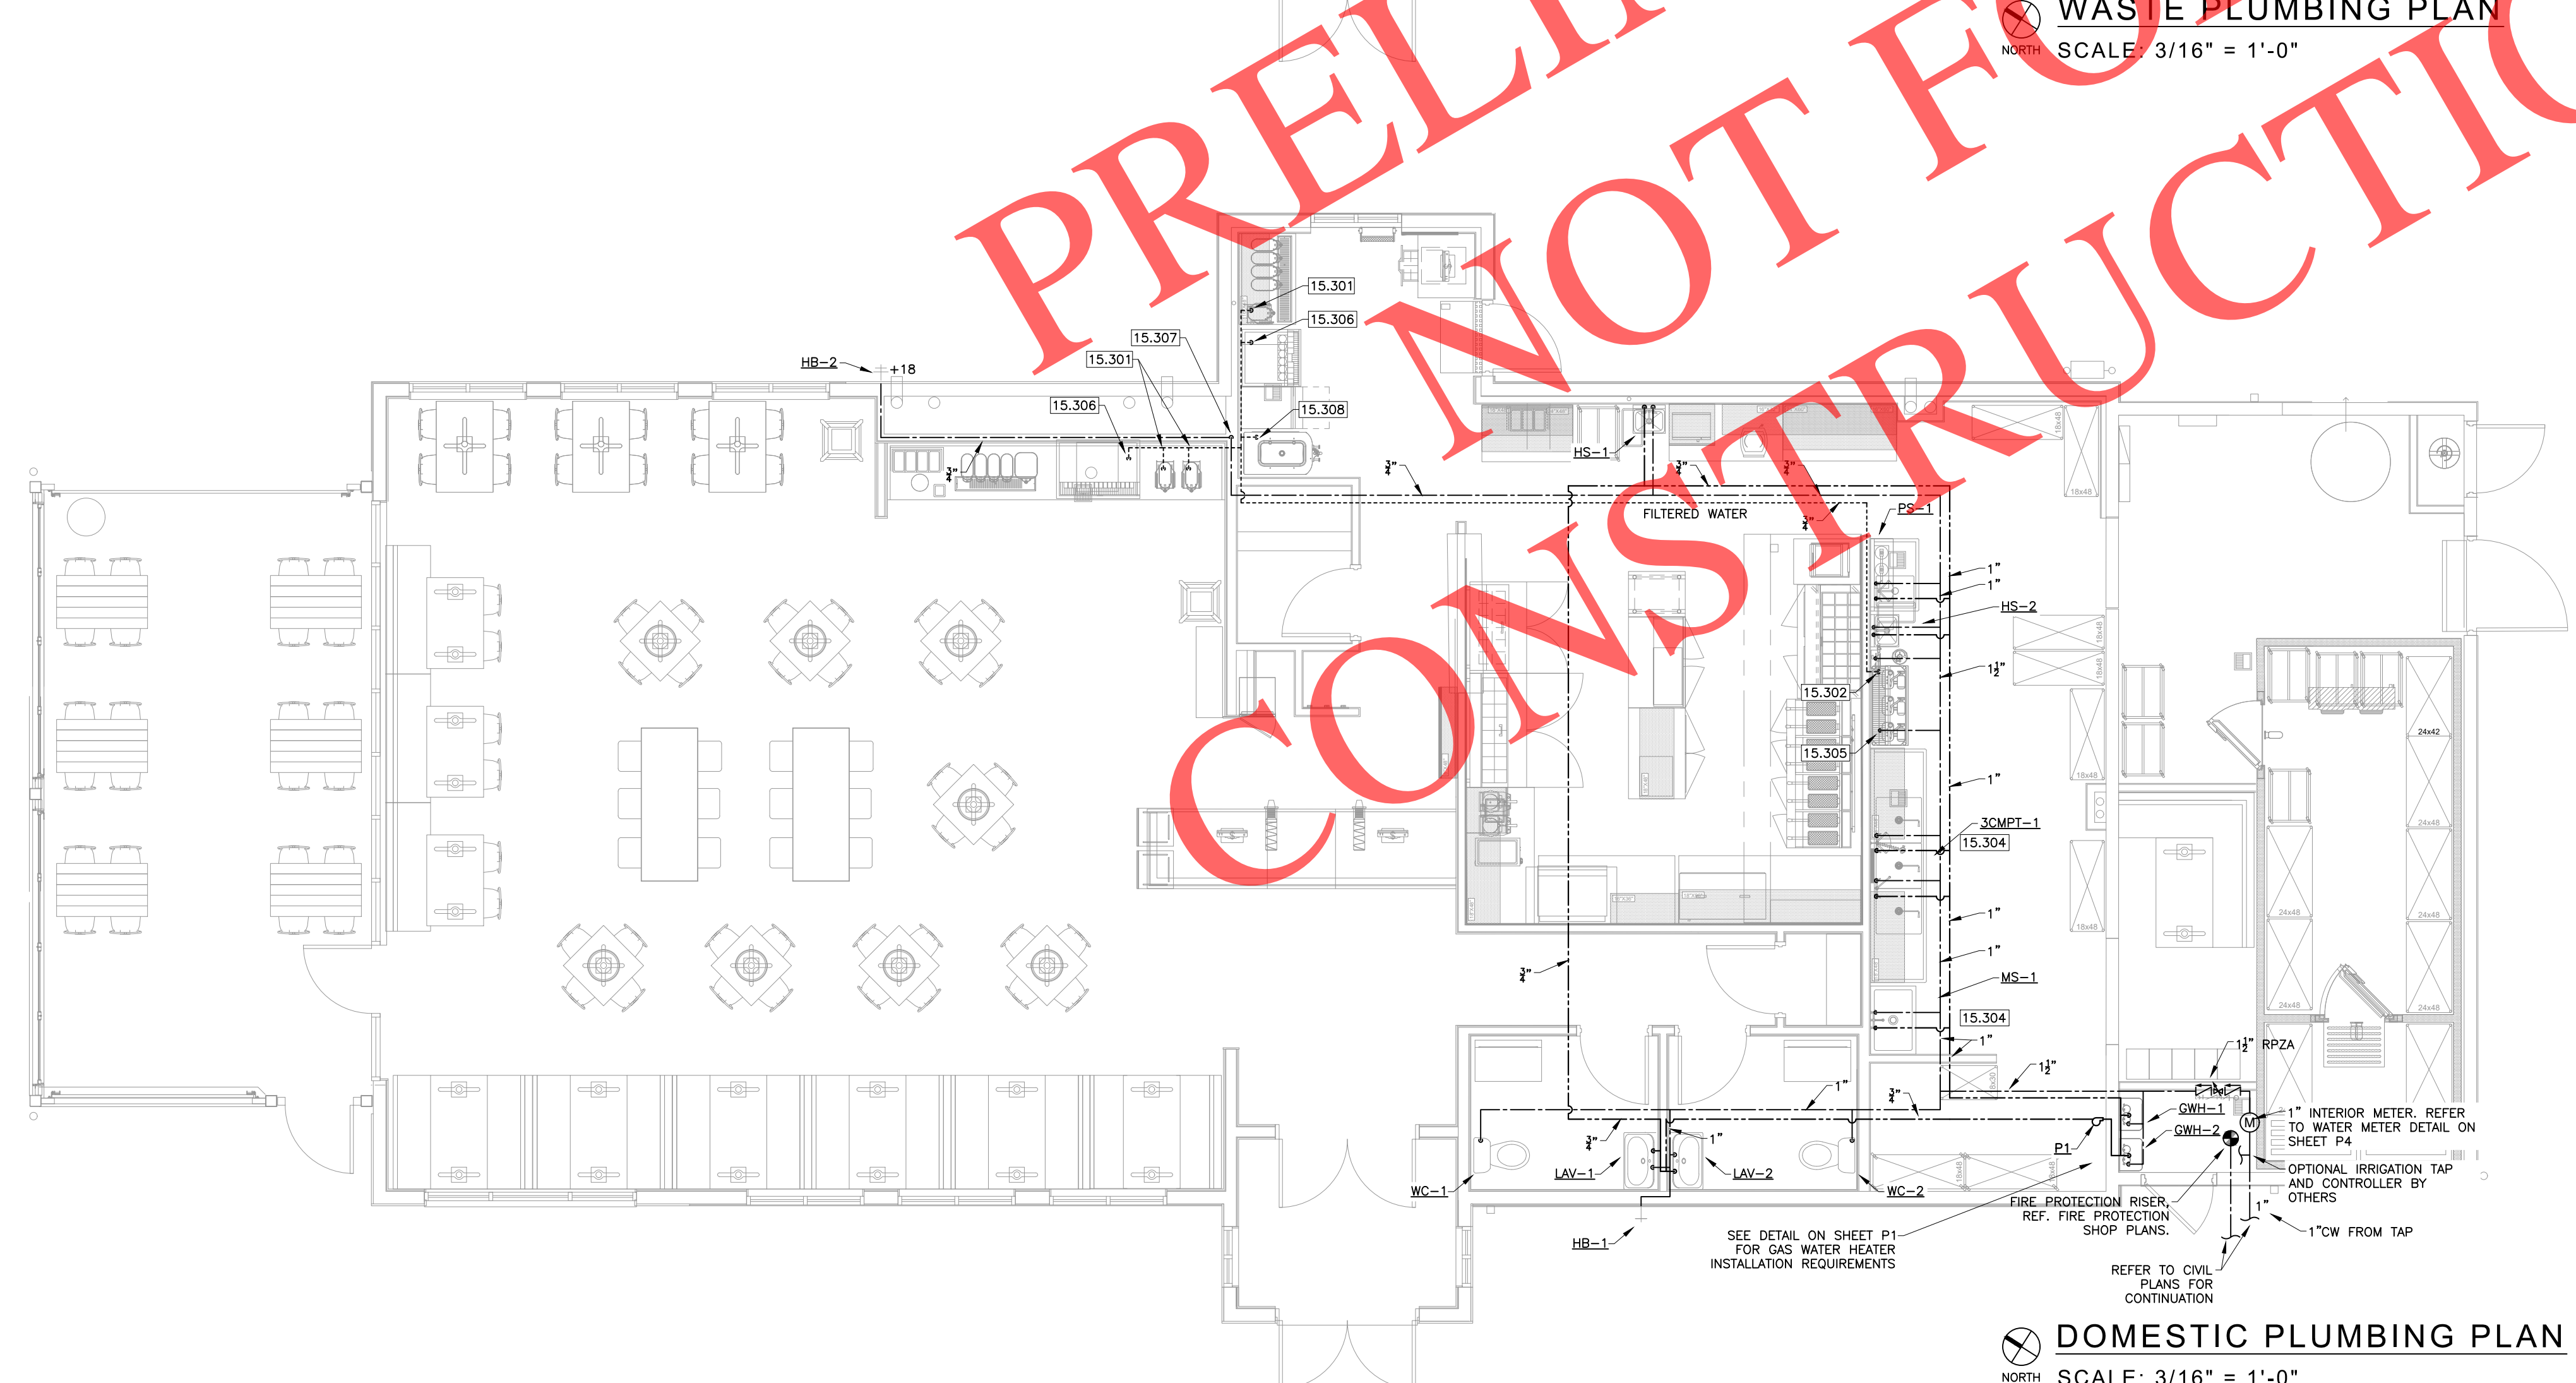

KEYNOTES - WATER

15.300	PROVIDE 1/2" FW W/ SHUT OFF TO ICE MAKER WITH (BP) PER SPECIALTY PLUMBING FIXTURE SCHEDULE. MOUNT RUN-OUT 60" A.F.F.
15.301	ROUTE 1/2" FW TO TEA BREWER WITH SHUT OFF VALVE AND (BP) PER SPECIALTY PLUMBING FIXTURE SCHEDULE. MOUNT RUN-OUT 24" A.F.F.
15.302	3/4" CW TO OWNER PROVIDED WATER FILTRATION SYSTEM. MOUNT TOP OF FILTER AT 7'-6" AFF.
15.304	SUPPLY PURE FORCE SANITIZING UNIT WITH AHJ APPROVED BACKFLOW PREVENTION.
15.305	PROVIDE 1/2" CW W/ SHUT OFF TO CARBONATOR WITH (BP) PER SPECIALTY PLUMBING FIXTURE SCHEDULE. NO COPPER DOWNSTREAM OF BP. MOUNT RUN-OUT 72" A.F.F. PROVIDE WITH MANUFACTURERS WATER FILTER AS REQUIRED.
15.306	PROVIDE 1/2" CW W/ SHUT OFF TO SODA DISPENSER ICE MAKER WITH (BP) PER SPECIALTY PLUMBING FIXTURE SCHEDULE. INSTALL PER MANUFACTURERS REQUIREMENTS. MOUNT RUN-OUT 60" A.F.F.
15.307	DROP 3/4" CW DOWN. ROUTE THRU CABINET TO FPWH. MOUNT 18" A.F.F.
15.308	PROVIDE CAPPED 1/2" FW LINE ABOVE CEILING FOR FUTURE ICE CREAM MACHINE.

PRELIMINARY
 NOT FOR
 CONSTRUCTION

WASTE PLUMBING PLAN
 SCALE: 3/16" = 1'-0"

DOMESTIC PLUMBING PLAN
 SCALE: 3/16" = 1'-0"

These plans are an instrument of service and are the property of the Engineer, and may not be duplicated, disclosed, or reproduced without the written consent of the Engineer. Copyrights and infringements will be enforced and prosecuted.

Life Changing Chicken
SLIM CHICKENS
 Chicken Tenders - Buffalo Wings - Sandwiches - Salads - Wraps
 Parcel: 2233-103-10-014
 S Parker Road & Pine Ln,
 Parker, CO


STIPULATION FOR REUSE
 THIS DRAWING WAS PREPARED FOR USE ON A SPECIFIC SITE AT HEREBYMAN, UT CONTEMPORANEOUSLY WITH ITS ISSUE DATE ON 06/12/2020, AND IT IS NOT SUITABLE FOR USE ON A DIFFERENT PROJECT SITE OR AT A LATER TIME. THE USE OF THIS DRAWING FOR REFERENCE OR EXAMPLE ON ANOTHER PROJECT REQUIRES THE SERVICES OF PROPERLY LICENSED ARCHITECTS AND ENGINEERS. REPRODUCTION OF THIS DRAWING FOR REUSE ON ANOTHER PROJECT IS NOT AUTHORIZED AND MAY BE CONTRARY TO THE LAW.

ISSUES / REVISIONS


NO.	DATE	DESCRIPTION
1	06/12/2020	CLIENT REVIEW

ISSUE DATE: 03/06/2020
 PROTO DATE: 11/01/18
 PROTO SIZE: 2800
 CHECKED BY: DRK
 DRAWN BY: BPD
 PROJECT #: 20139

SHEET NAME
PLUMBING
 SHEET NUMBER

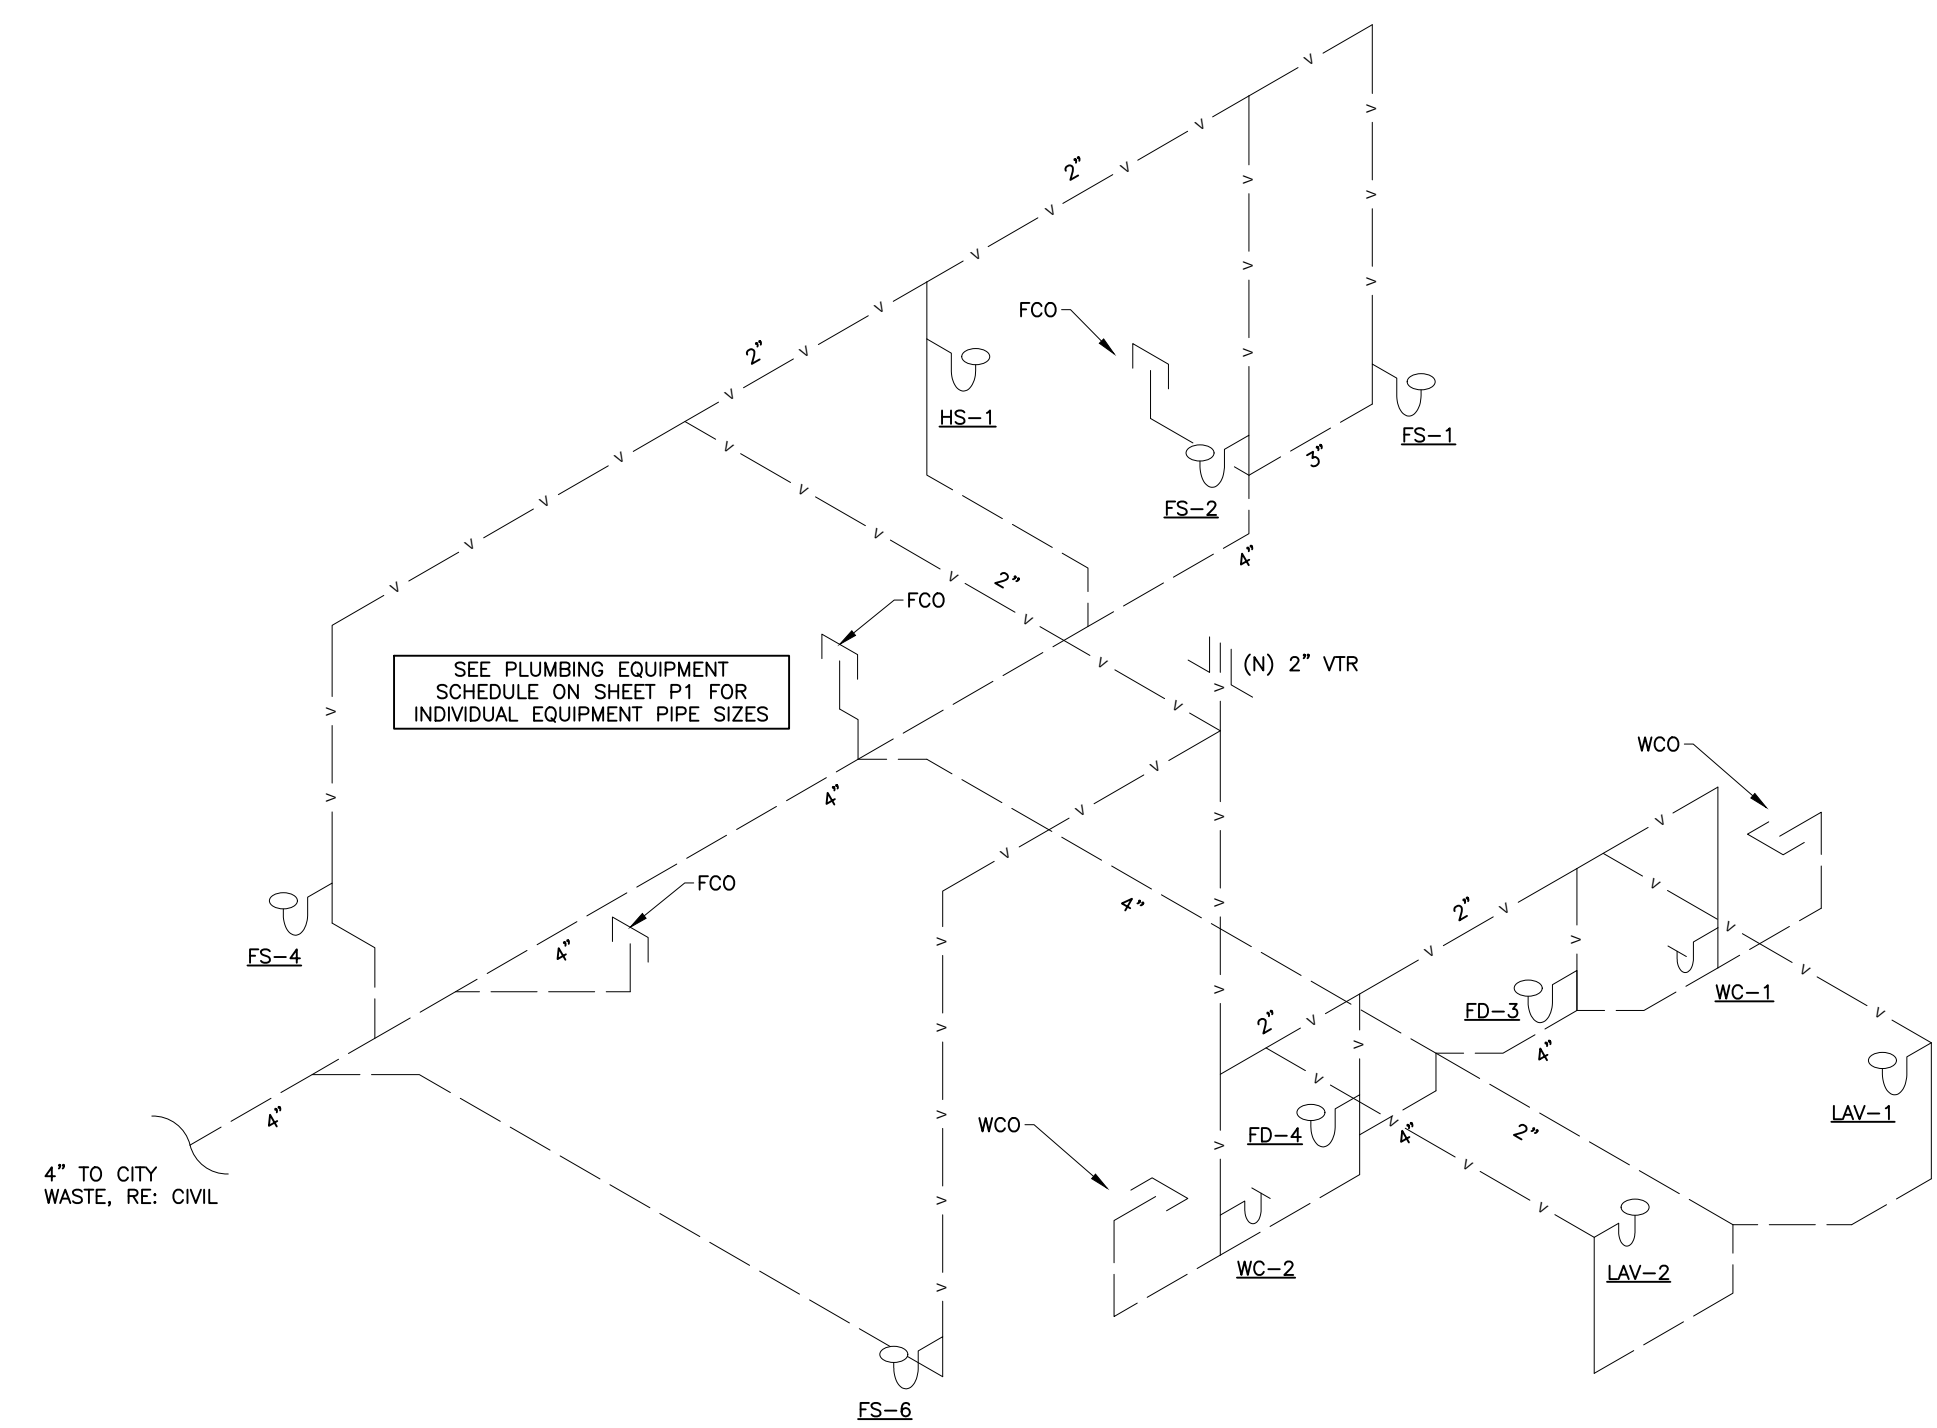


WASTE & VENT PIPING ISOMETRIC
 NOT TO SCALE

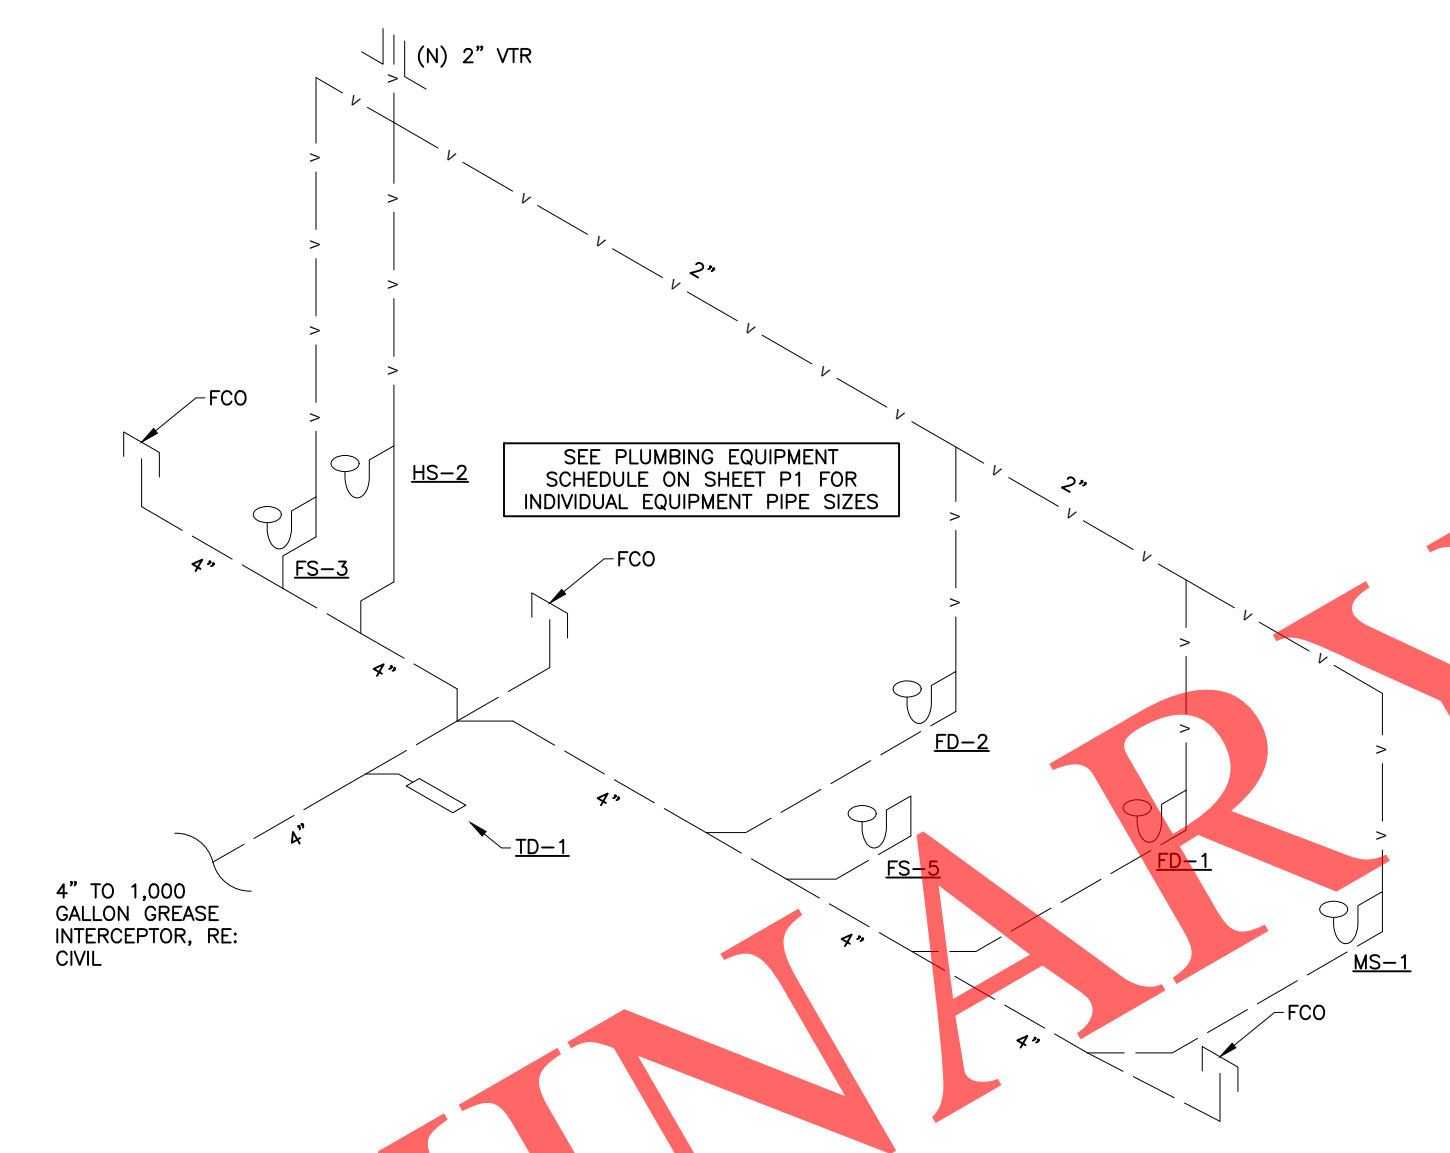

GREASE & VENT PIPING ISOMETRIC
 NOT TO SCALE

PRELIMINARY
 NOT FOR
 CONSTRUCTION

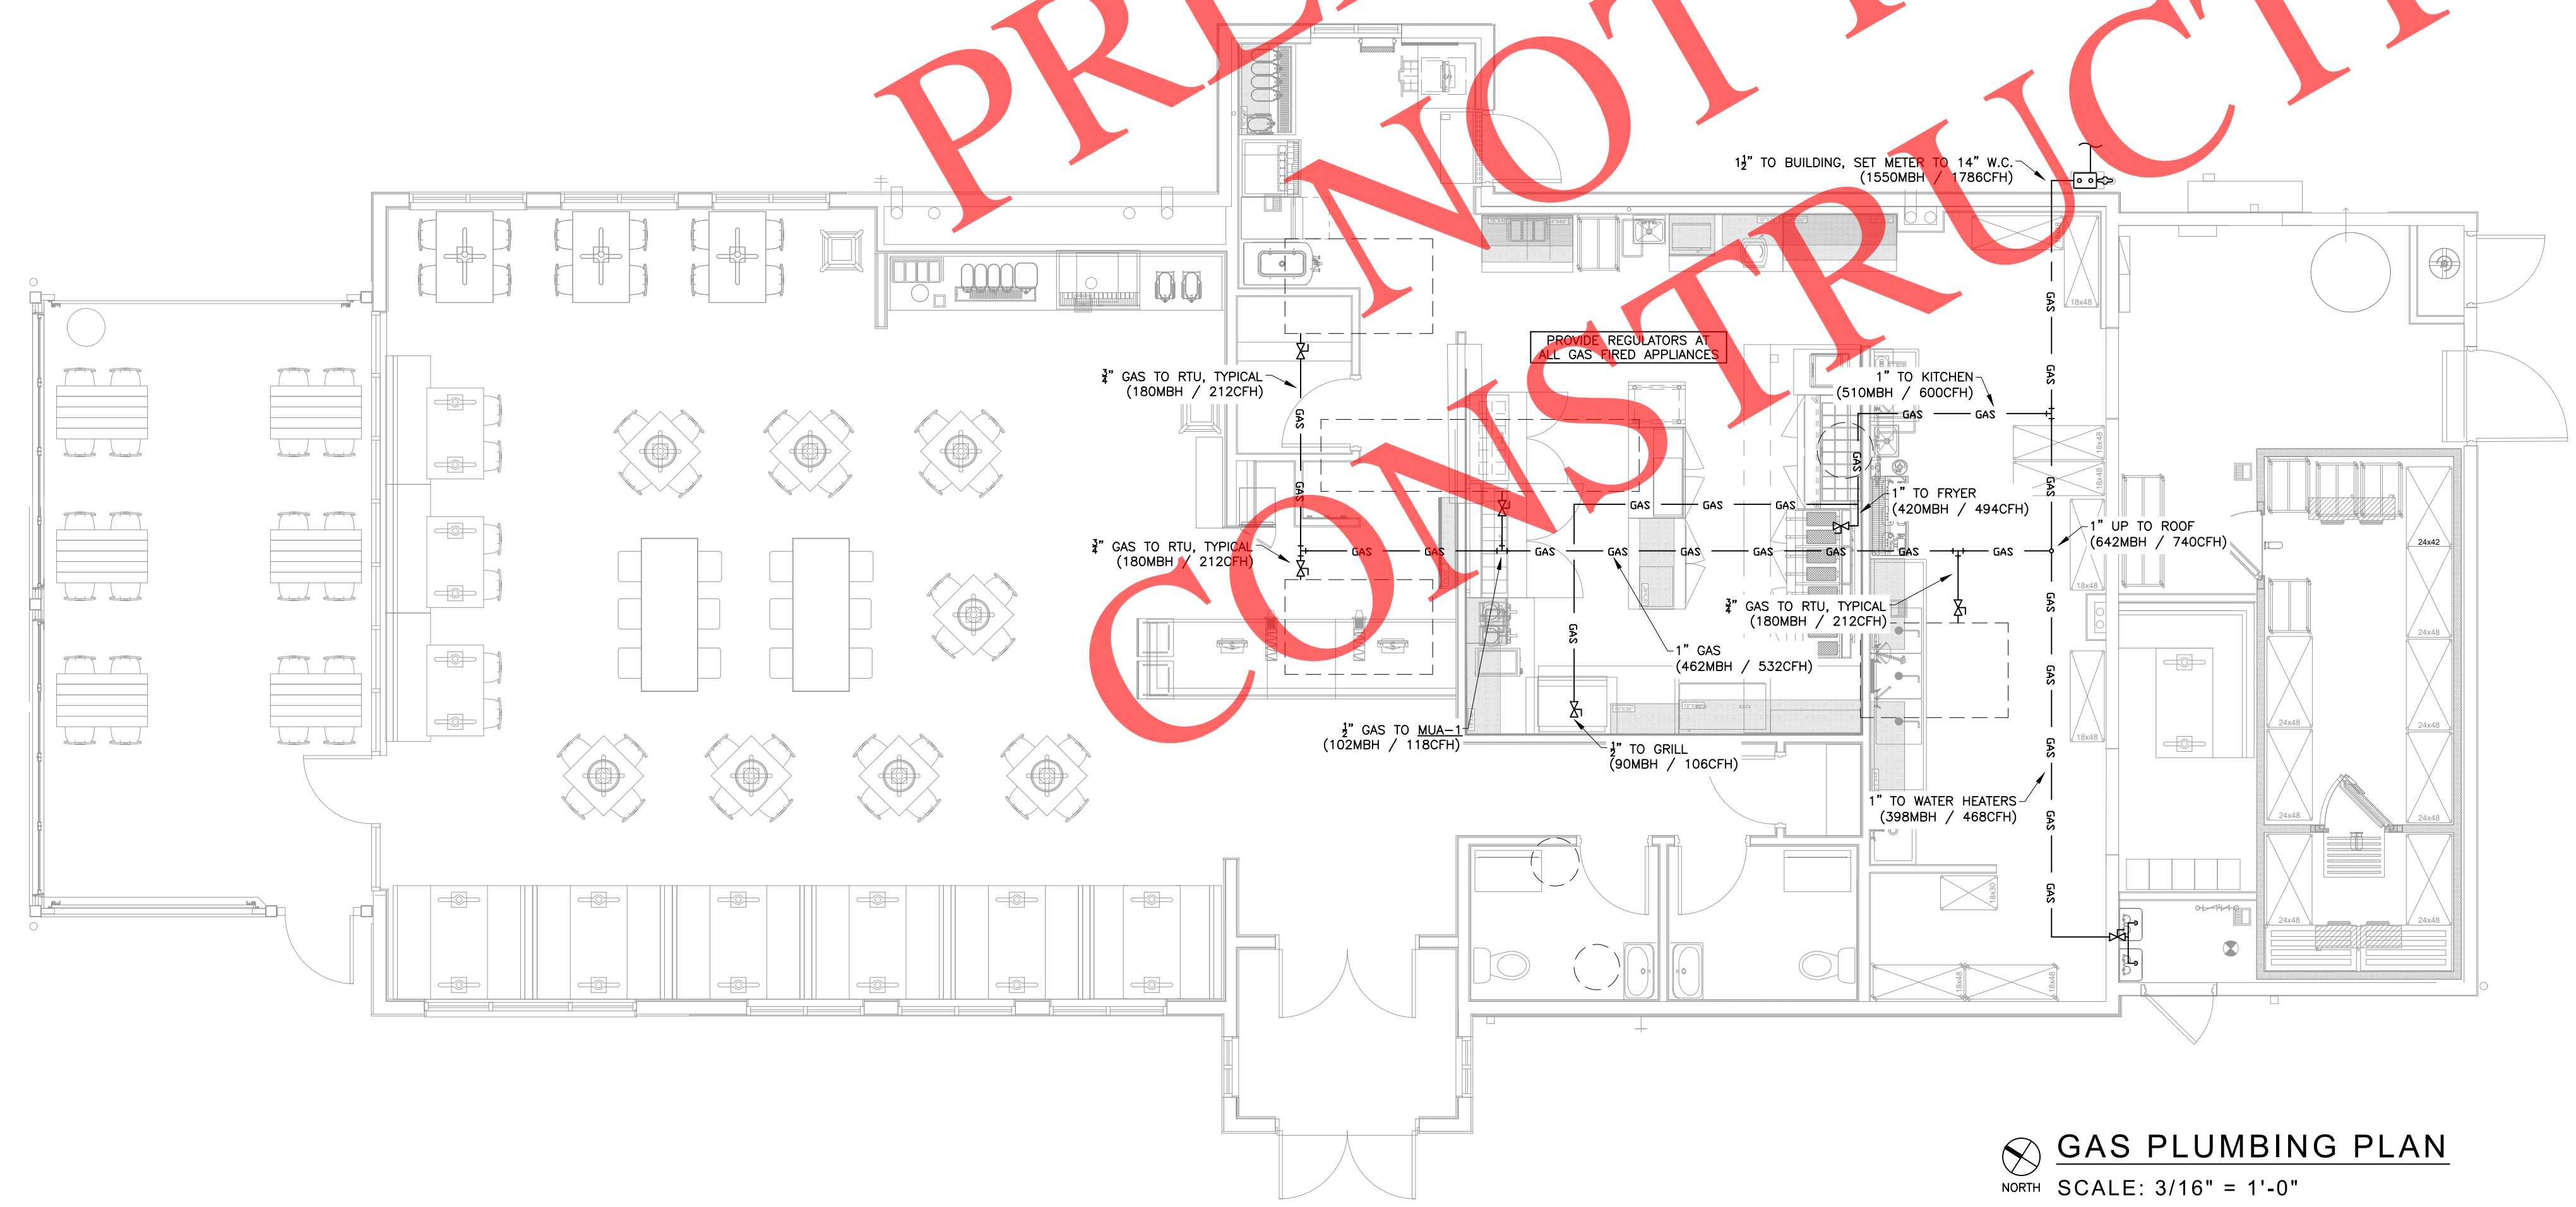

GAS PLUMBING PLAN
 NORTH SCALE: 3/16" = 1'-0"

These plans are an instrument of service and are the property of the Engineer, and may not be duplicated, disclosed, or reproduced without the written consent of the Engineer. Copyrights and infringements will be enforced and prosecuted.

Life Changing Chicken
SLIM CHICKENS
 Chicken Tenders - Buffalo Wings - Sandwiches - Subs - Wraps
 Parcel: 2233-103-10-014
 S Parker Road & Pine Ln,
 Parker, CO


STIPULATION FOR REUSE
 THIS DRAWING WAS PREPARED FOR USE ON A SPECIFIC SITE AT HEREBYMAN, UT CONTEMPORANEOUSLY WITH ITS ISSUE DATE ON 03/06/2020, AND IT IS NOT SUITABLE FOR USE ON A DIFFERENT PROJECT SITE OR AT A LATER TIME. USE OF THIS DRAWING FOR REFERENCE OR EXAMPLE ON ANOTHER PROJECT REQUIRES THE SERVICES OF PROPERLY LICENSED ARCHITECTS AND ENGINEERS. REPRODUCTION OF THIS DRAWING FOR REUSE ON ANOTHER PROJECT IS NOT AUTHORIZED AND MAY BE CONTRARY TO THE LAW.

ISSUES / REVISIONS


NO.	DATE	DESCRIPTION
1	06/12/2020	CLIENT REVIEW

ISSUE DATE: 03/06/2020
 PROTO DATE: 11/01/18
 PROTO SIZE: 2800
 CHECKED BY: DRK
 DRAWN BY: BPD
 PROJECT #: 20139


SHEET NAME
PLUMBING
 SHEET NUMBER

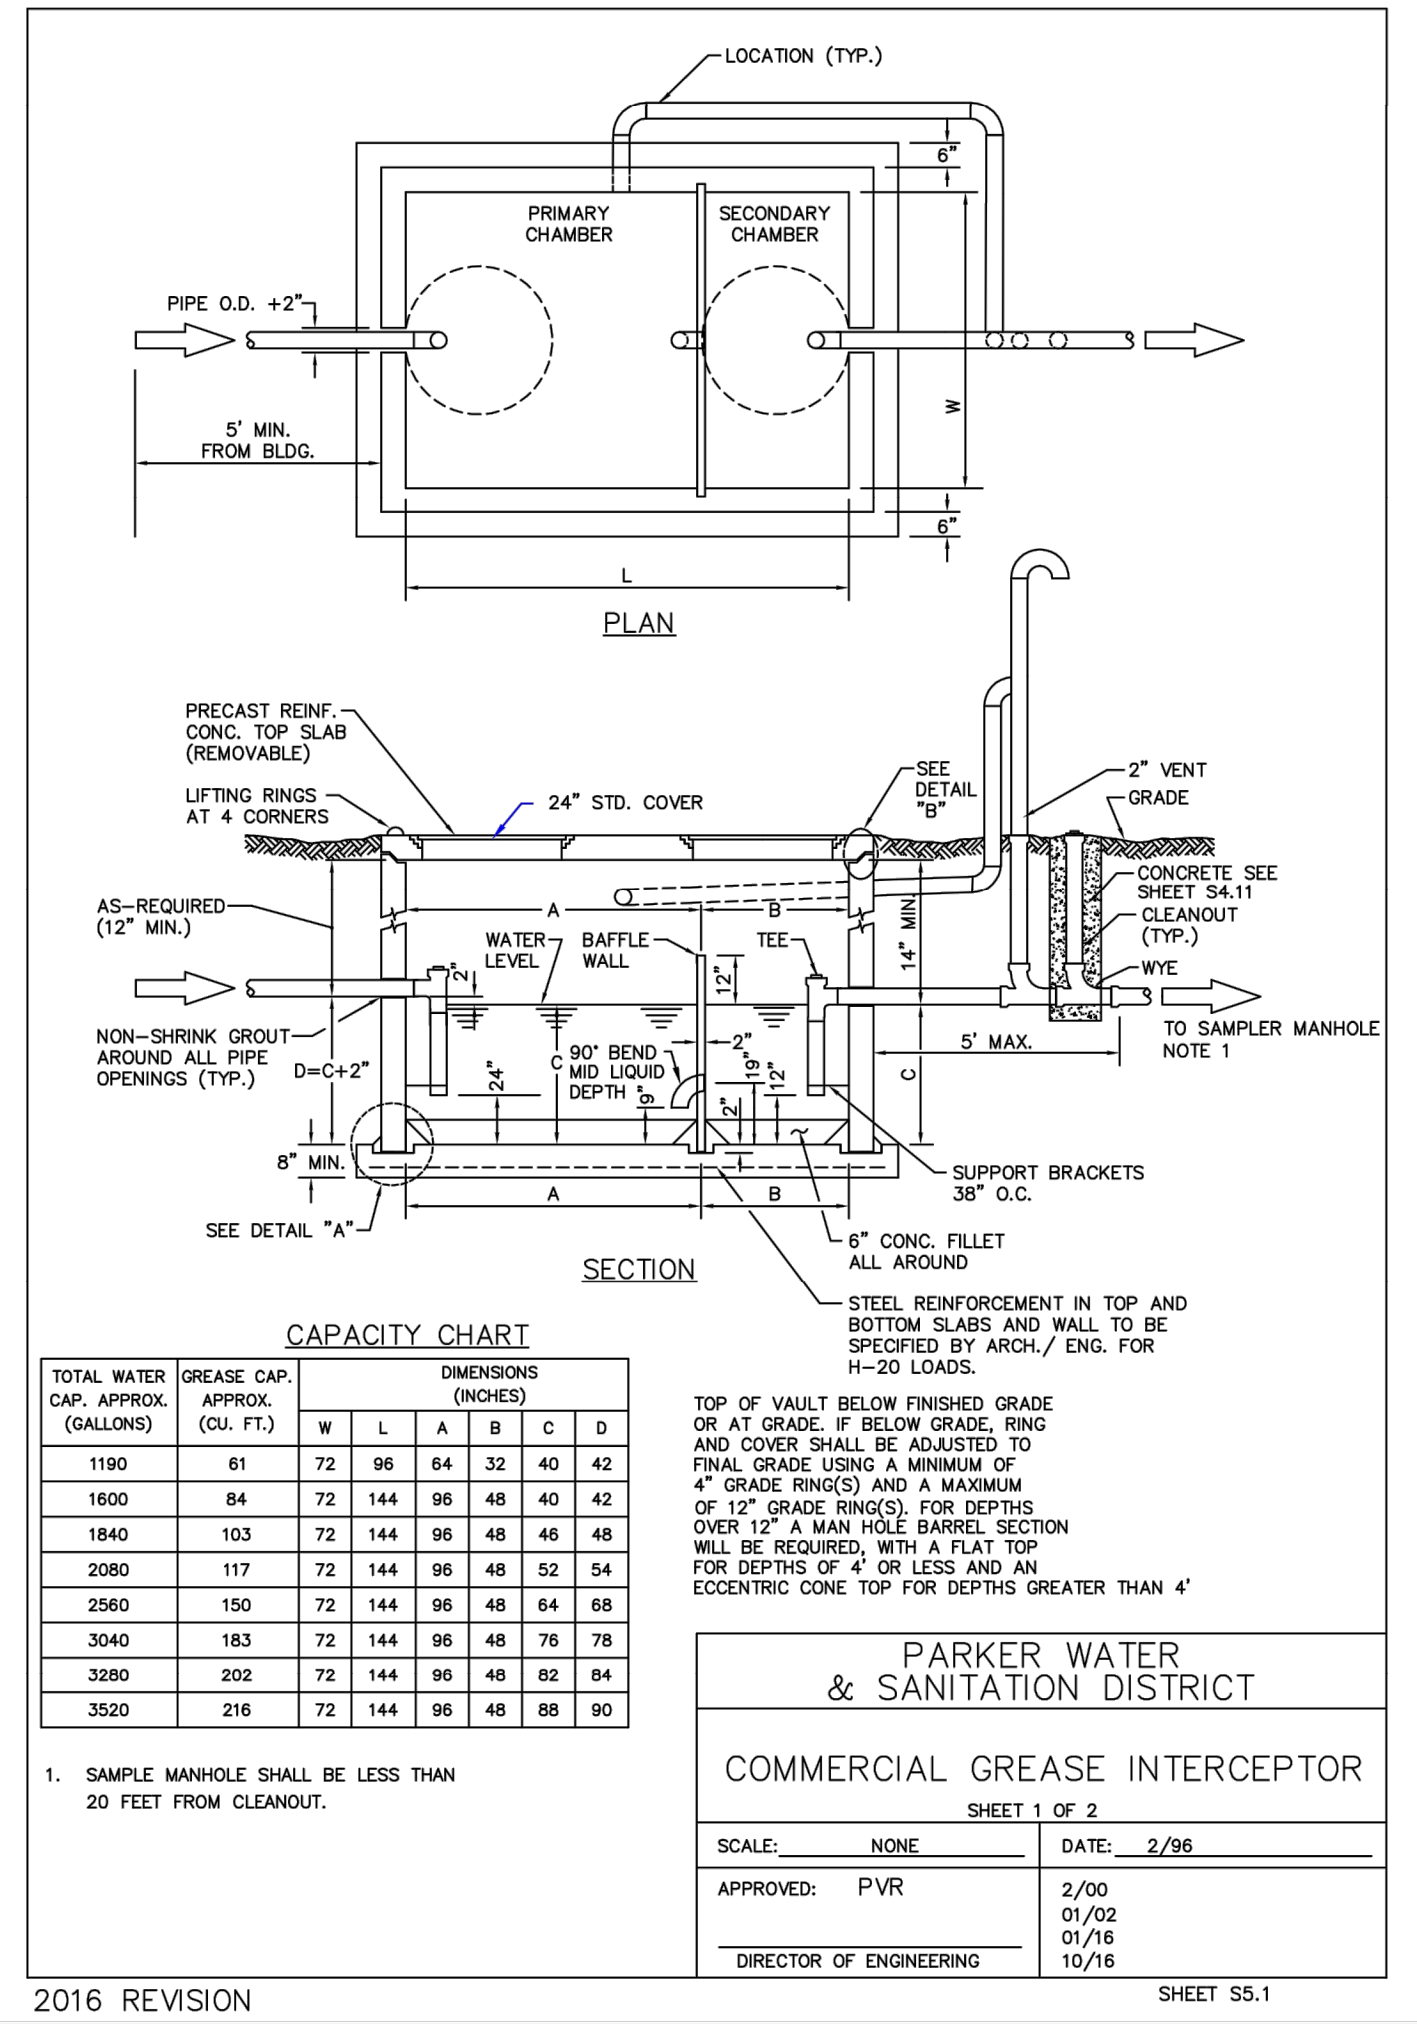

GREASE INTERCEPTOR DETAIL
 NOT TO SCALE

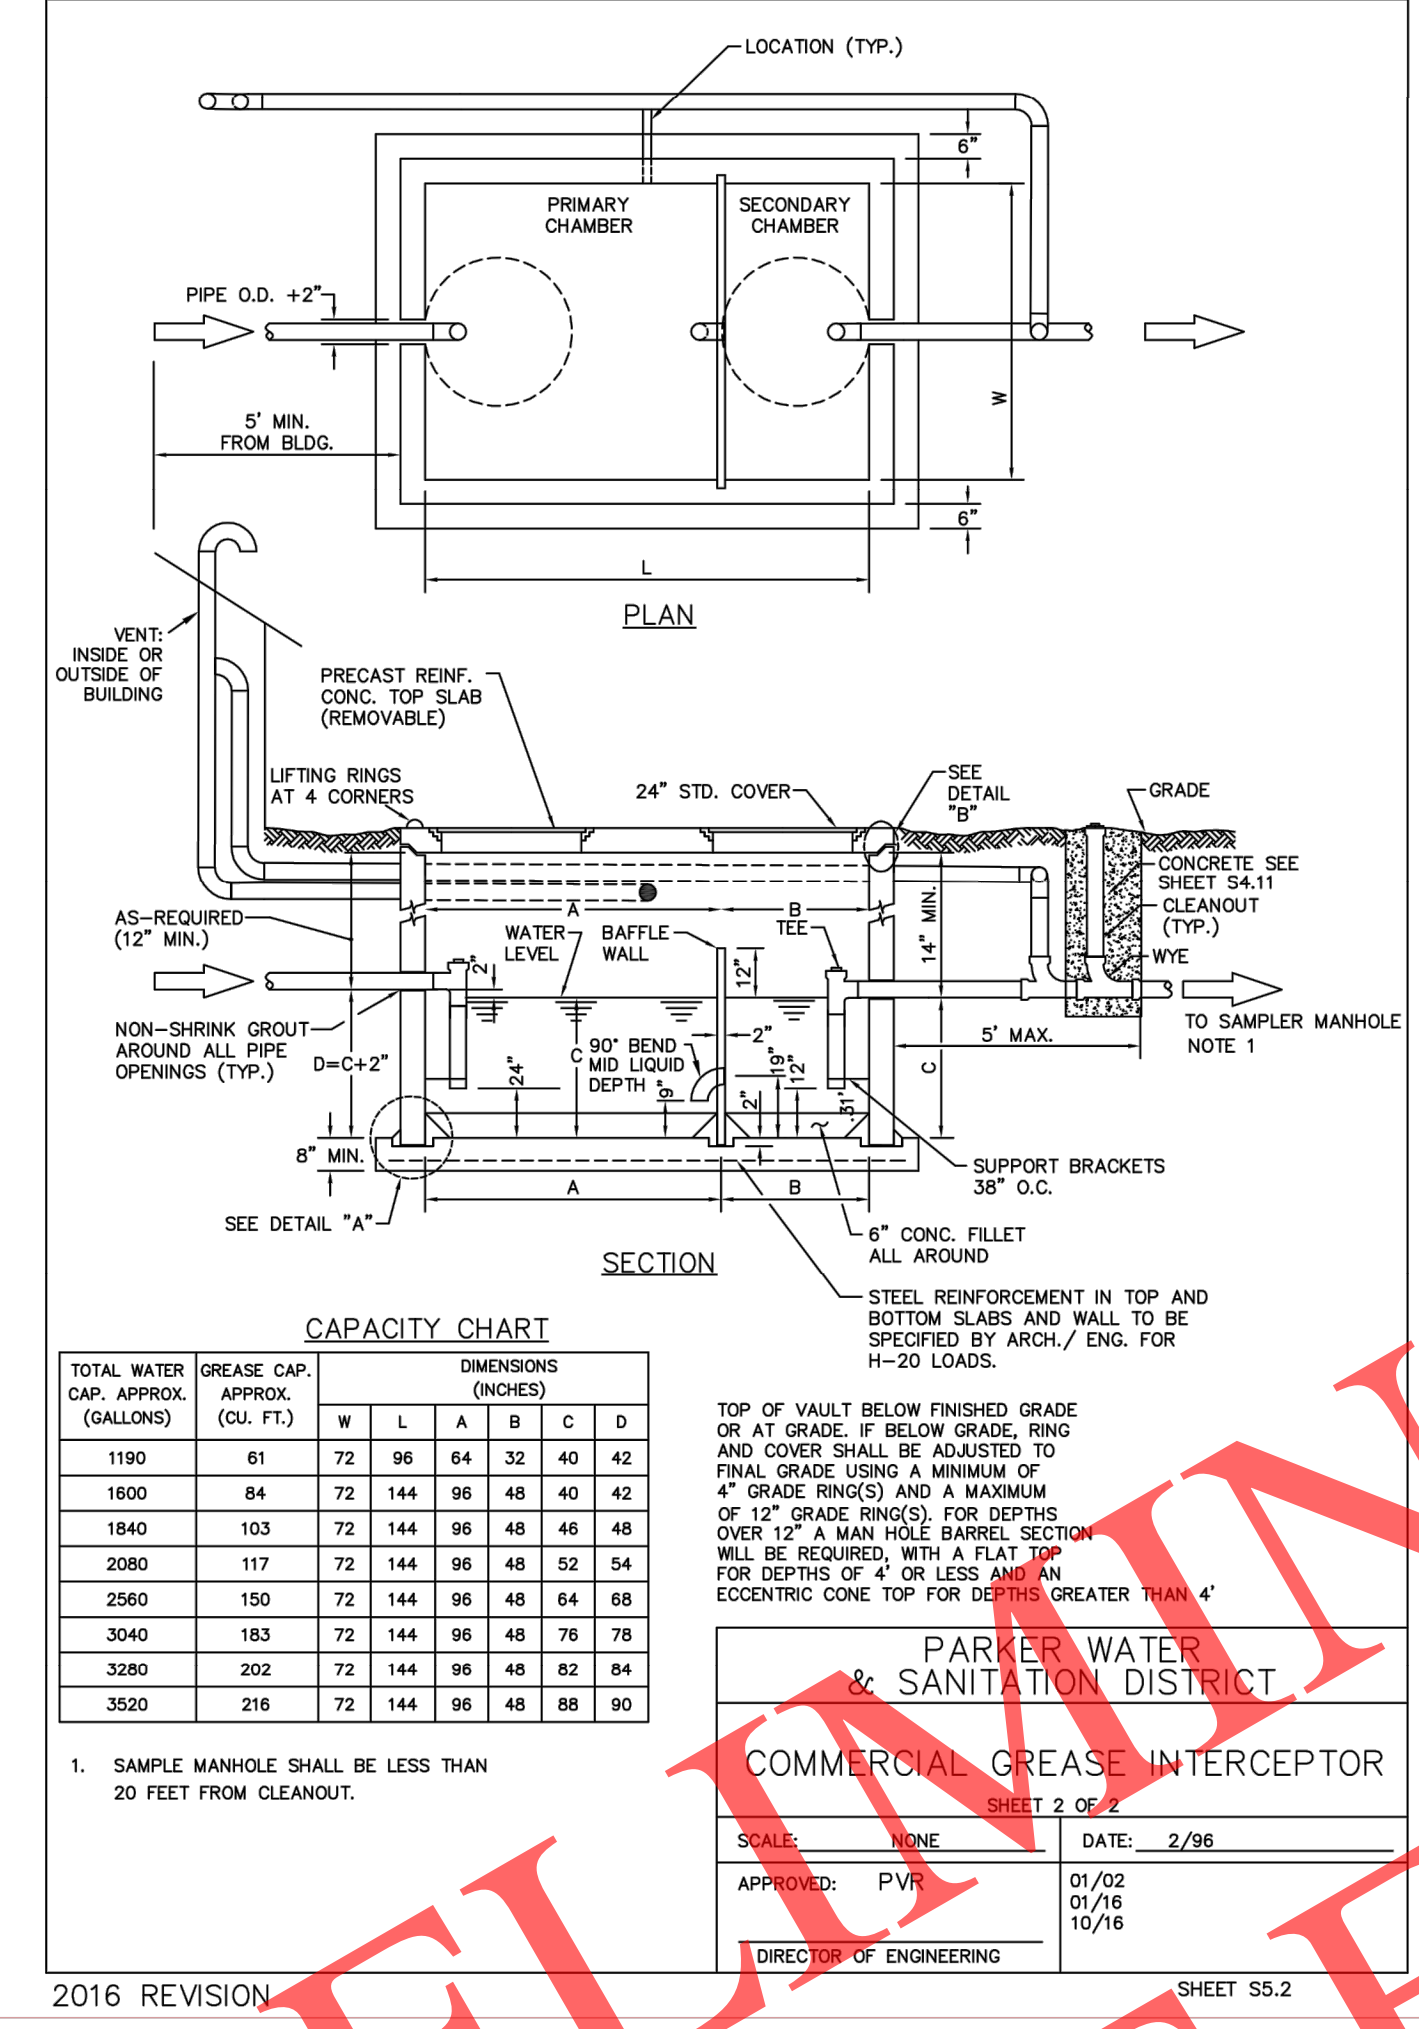

GREASE INTERCEPTOR DETAIL
 NOT TO SCALE

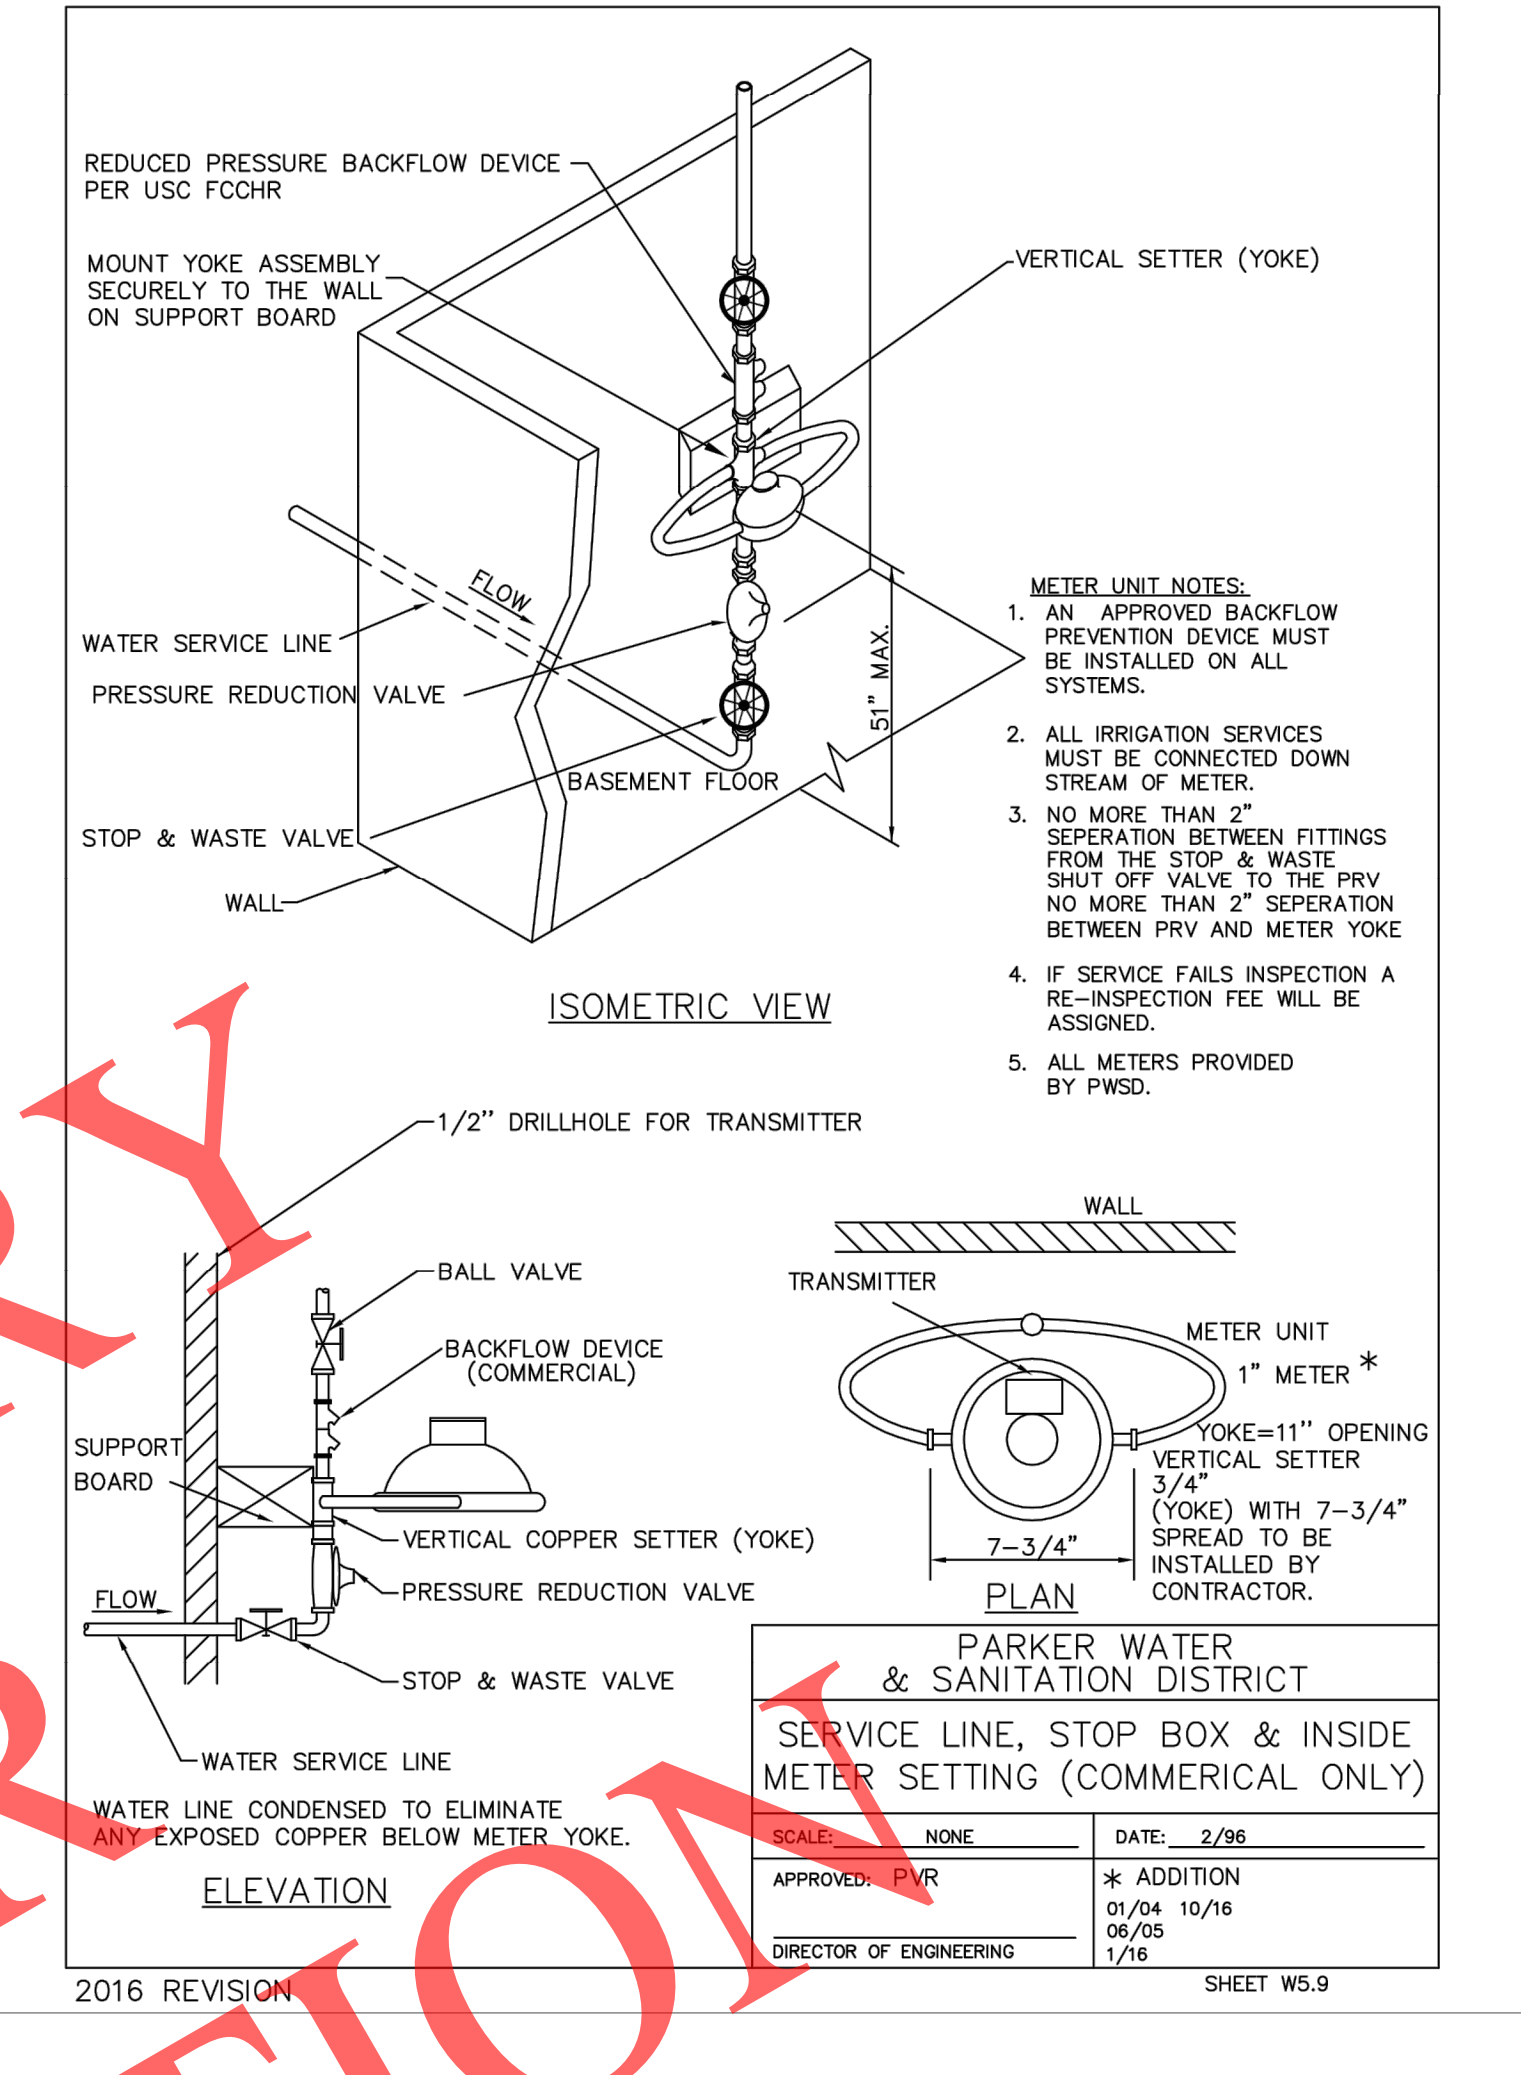

INTERIOR WATER METER DETAIL
 NOT TO SCALE

PRELIMINARY
 NOT FOR CONSTRUCTION

These plans are an instrument of service and are the property of the Engineer, and may not be duplicated, disclosed, or reproduced without the written consent of the Engineer. Copyrights and infringements will be enforced and prosecuted.

Life Changing Chickens
SLIM CHICKENS
 Chicken Tenders - Buffalo Wings - Sandwiches - Subs - Wraps
 Parcel: 2233-103-10-014
 S Parker Road & Pine Ln,
 Parker, CO

STIPULATION FOR REUSE
 THIS DRAWING WAS PREPARED FOR USE ON A SPECIFIC SITE AT HEREBYMAN, UT CONTEMPORANEOUSLY WITH ITS ISSUE DATE ON 03/02/2020, AND IT IS NOT SUITABLE FOR USE ON A DIFFERENT PROJECT SITE OR AT A LATER TIME. USE OF THIS DRAWING FOR REFERENCE OR EXAMPLE ON ANOTHER PROJECT REQUIRES THE SERVICES OF PROPERLY LICENSED ARCHITECTS AND ENGINEERS. REPRODUCTION OF THIS DRAWING FOR REUSE ON ANOTHER PROJECT IS NOT AUTHORIZED AND MAY BE CONTRARY TO THE LAW.

ISSUES / REVISIONS	MID/YYYY	ISSUE
1	06/12/2020	CLIENT REVIEW

ISSUE DATE: 03/06/2020
 PROTO DATE: 11/01/18
 PROTO SIZE: 2800
 CHECKED BY: DRK
 DRAWN BY: BPD
 PROJECT # 20139

SHEET NAME

PLUMBING

SHEET NUMBER