


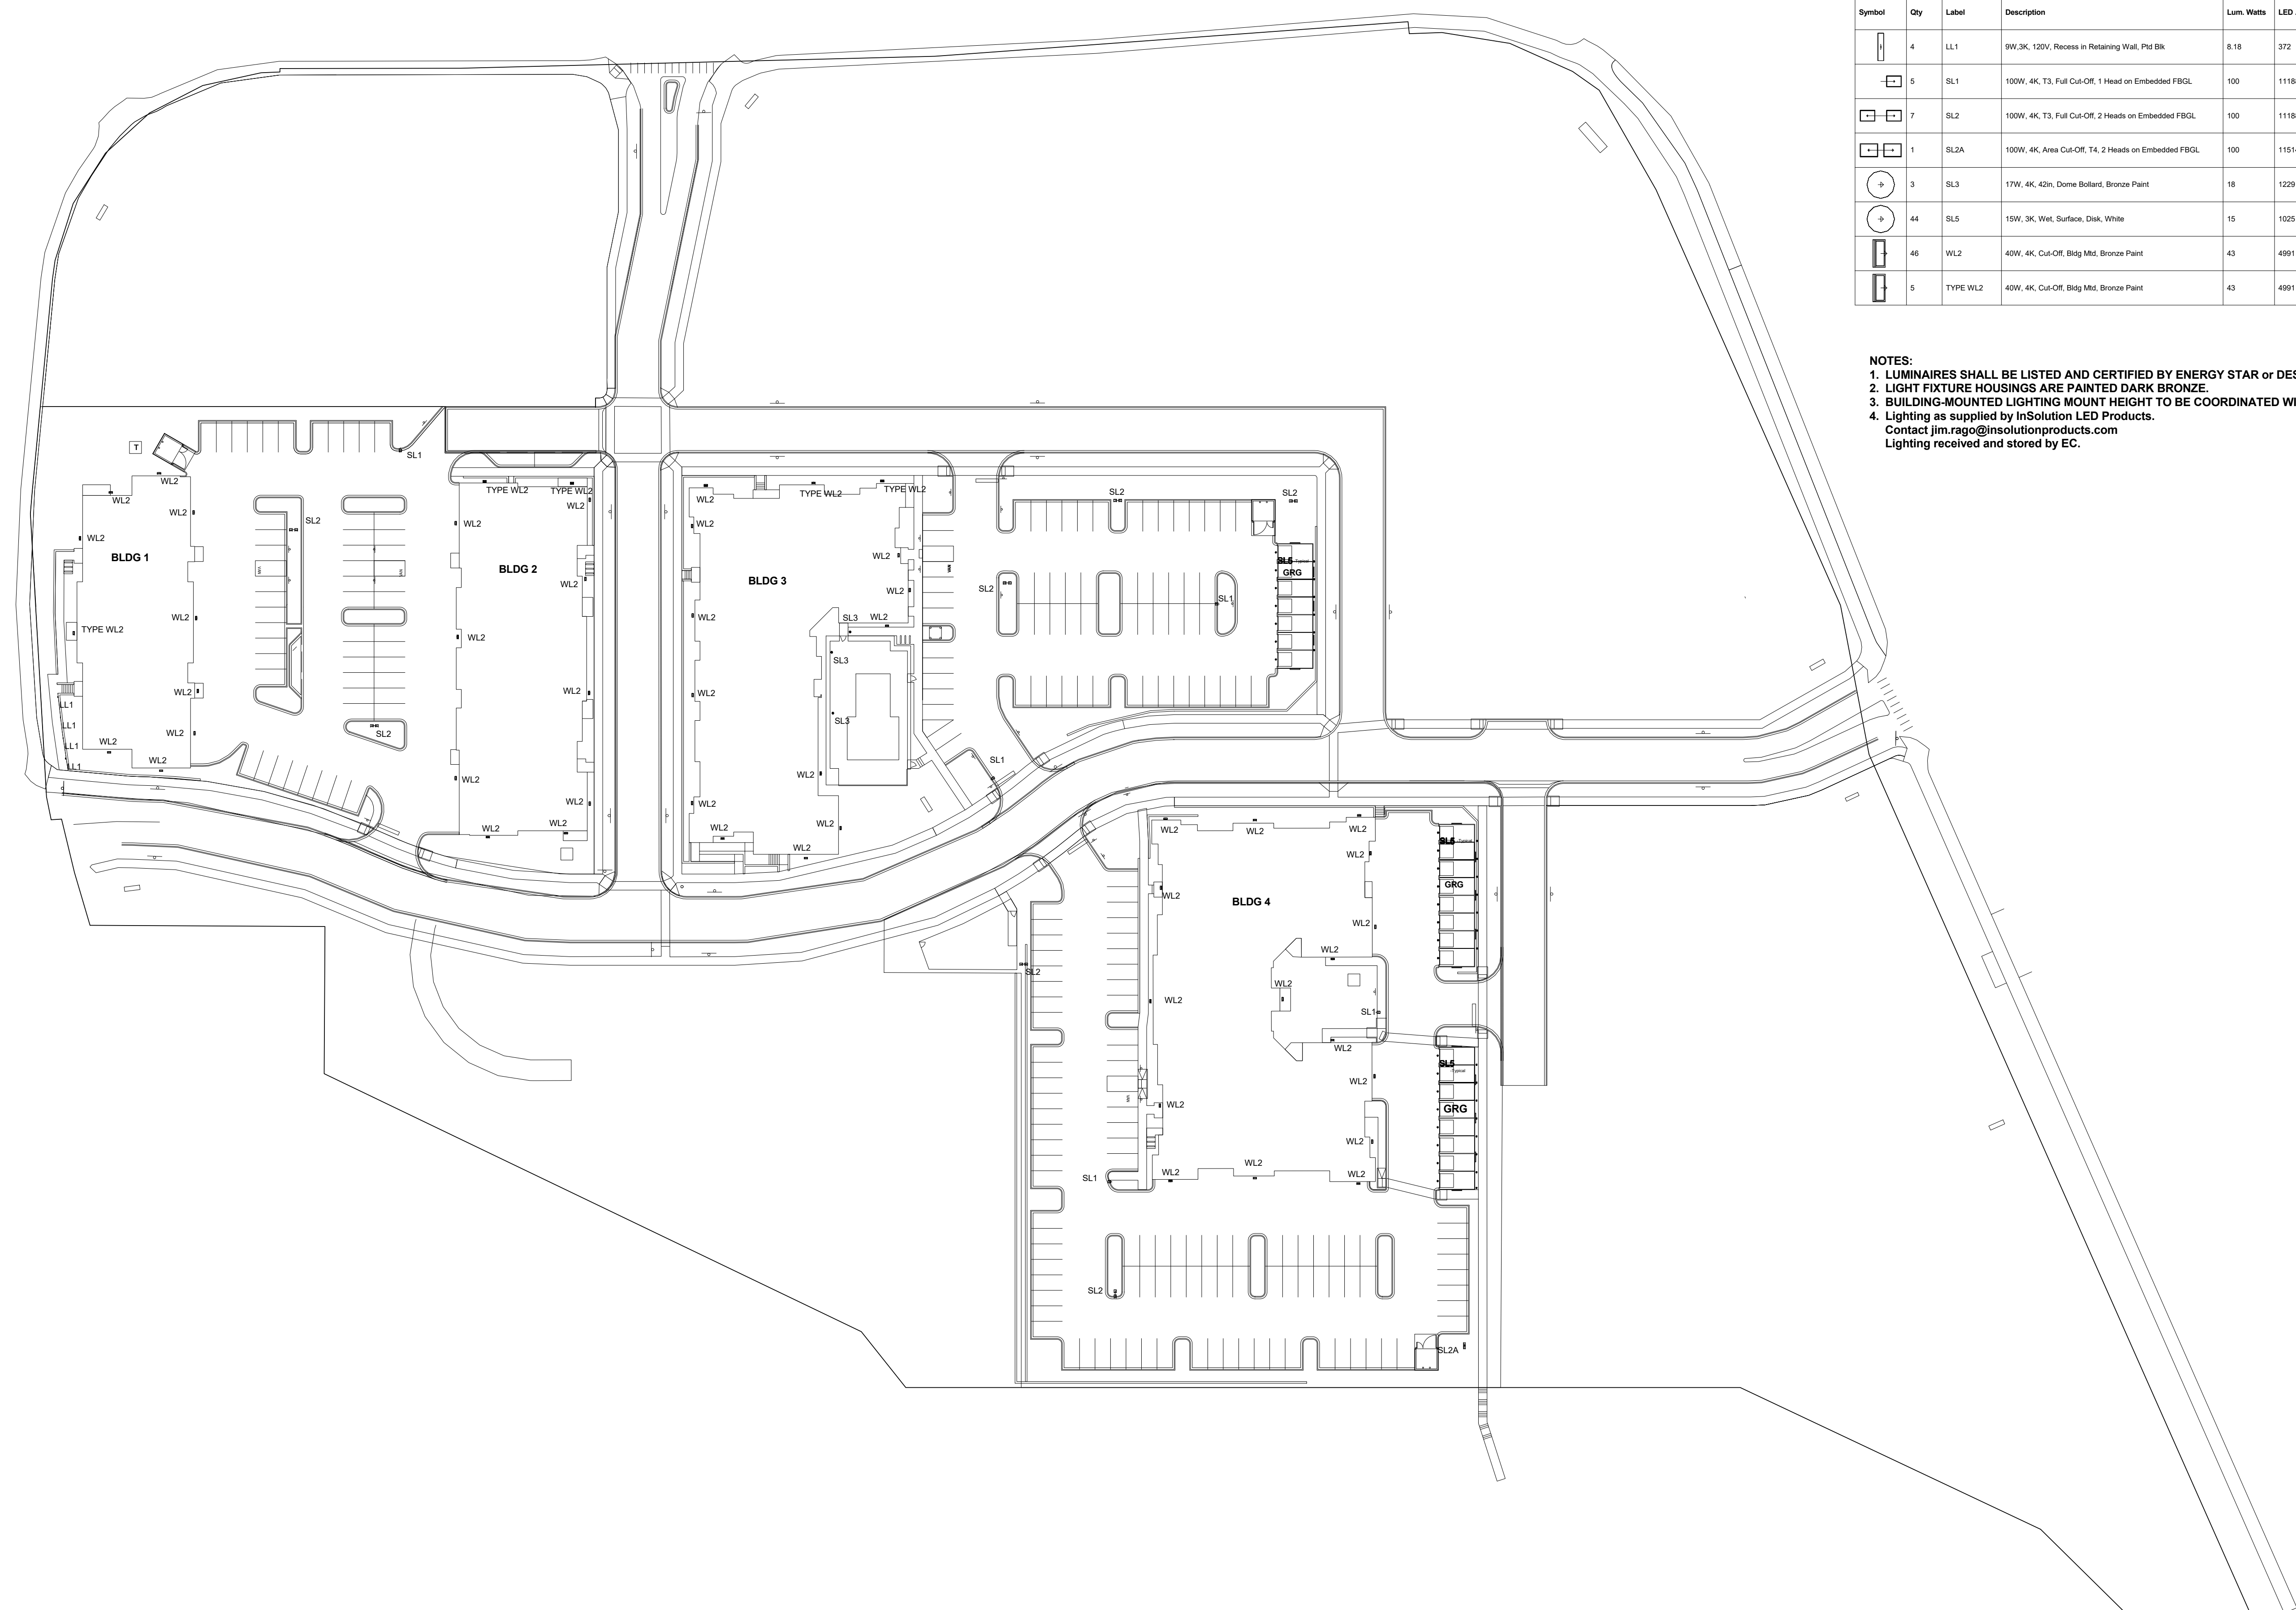


InSolution LLC
 5157 E 64th St
 Indianapolis, IN 46220
 jim.rago@insolutionproducts.com

Symbol	Qty	Label	Description	Lum. Watts	LED Lumens	BUG Rating	HEIGHT AFG
	4	LL1	9W, 3K, 120V, Recess in Retaining Wall, Pld BK	8.18	372	B0-U3-G1	1.5
	5	SL1	100W, 4K, T3, Full Cut-Off, 1 Head on Embedded FBGL	100	11188	B2-U0-G2	25
	7	SL2	100W, 4K, T3, Full Cut-Off, 2 Heads on Embedded FBGL	100	11188	B2-U0-G2	25
	1	SL2A	100W, 4K, Area Cut-Off, T4, 2 Heads on Embedded FBGL	100	11514	B2-U0-G2	25
	3	SL3	17W, 4K, 42in, Dome Bollard, Bronze Paint	18	1229	B1-U3-G1	3.5
	44	SL5	15W, 3K, Wet, Surface, Disk, White	15	1025	B1-U2-G1	8
	46	WL2	40W, 4K, Cut-Off, Bldg Mid, Bronze Paint	43	4991	B1-U0-G1	20
	5	TYPE WL2	40W, 4K, Cut-Off, Bldg Mid, Bronze Paint	43	4991	B1-U0-G1	

NOTES:
 1. LUMINAIRES SHALL BE LISTED AND CERTIFIED BY ENERGY STAR or DESIGNLIGHTS CONSORTIUM.
 2. LIGHT FIXTURE HOUSINGS ARE PAINTED DARK BRONZE.
 3. BUILDING-MOUNTED LIGHTING MOUNT HEIGHT TO BE COORDINATED WITH ALL TRADES AND OWNER.
 4. Lighting as supplied by InSolution LED Products.
 Contact jim.rago@insolutionproducts.com
 Lighting received and stored by EC.



FOR REVIEW ONLY
 NOT FOR
 CONSTRUCTION

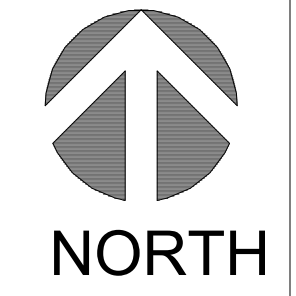

#	Date	Comments
	04/19/2021	Lighting Responses to Staff Comments 03

Drawn By:	Checked By:	Date:
j.rago	j.rago	04/19/2021

Scale: 1in = 50ft


PARKER AND PINE FILING NO.2
 LOTS 1-3 PARKER, CO
 SITE LIGHTING PLAN



InSolution LLC
 5157 E 64th St
 Indianapolis, IN 46220
 jim.rago@insolutionproducts.com

Symbol	Qty	Label	Description	Lum. Watts	LED Lumens	BUG Rating	HEIGHT AFG
[Symbol]	4	LL1	9W, 3K, 120V, Recess in Retaining Wall, Pld Bk	8.18	372	B0-US-G1	1.5
[Symbol]	5	SL1	100W, 4K, T3, Full Cut-Off, 1 Head on Embedded FBGL	100	11188	B2-U0-G2	25
[Symbol]	7	SL2	100W, 4K, T3, Full Cut-Off, 2 Heads on Embedded FBGL	100	11188	B2-U0-G2	25
[Symbol]	1	SL2A	100W, 4K, Area Cut-Off, T4, 2 Heads on Embedded FBGL	100	11544	B2-U0-G2	25
[Symbol]	3	SL3	17W, 4K, 42in, Dome Bollard, Bronze Paint	18	1229	B1-US-G1	3.5
[Symbol]	44	SL5	15W, 3K, Wet, Surface, Disk, White	15	1025	B1-US-G1	8
[Symbol]	46	WL2	40W, 4K, Cut-Off, Bldg Mtd, Bronze Paint	43	4991	B1-U0-G1	20
[Symbol]	5	TYPE WL2	40W, 4K, Cut-Off, Bldg Mtd, Bronze Paint	43	4991	B1-U0-G1	

NOTES:
 1. LUMINAIRES SHALL BE LISTED AND CERTIFIED BY ENERGY STAR or DESIGNLIGHTS CONSORTIUM.
 2. LIGHT FIXTURE HOUSINGS ARE PAINTED DARK BRONZE.
 3. BUILDING-MOUNTED LIGHTING MOUNT HEIGHT TO BE COORDINATED WITH ALL TRADES AND OWNER REP.
 4. Lighting as supplied by InSolution LED Products.
 Contact jim.rago@insolutionproducts.com
 Lighting received and stored by EC.

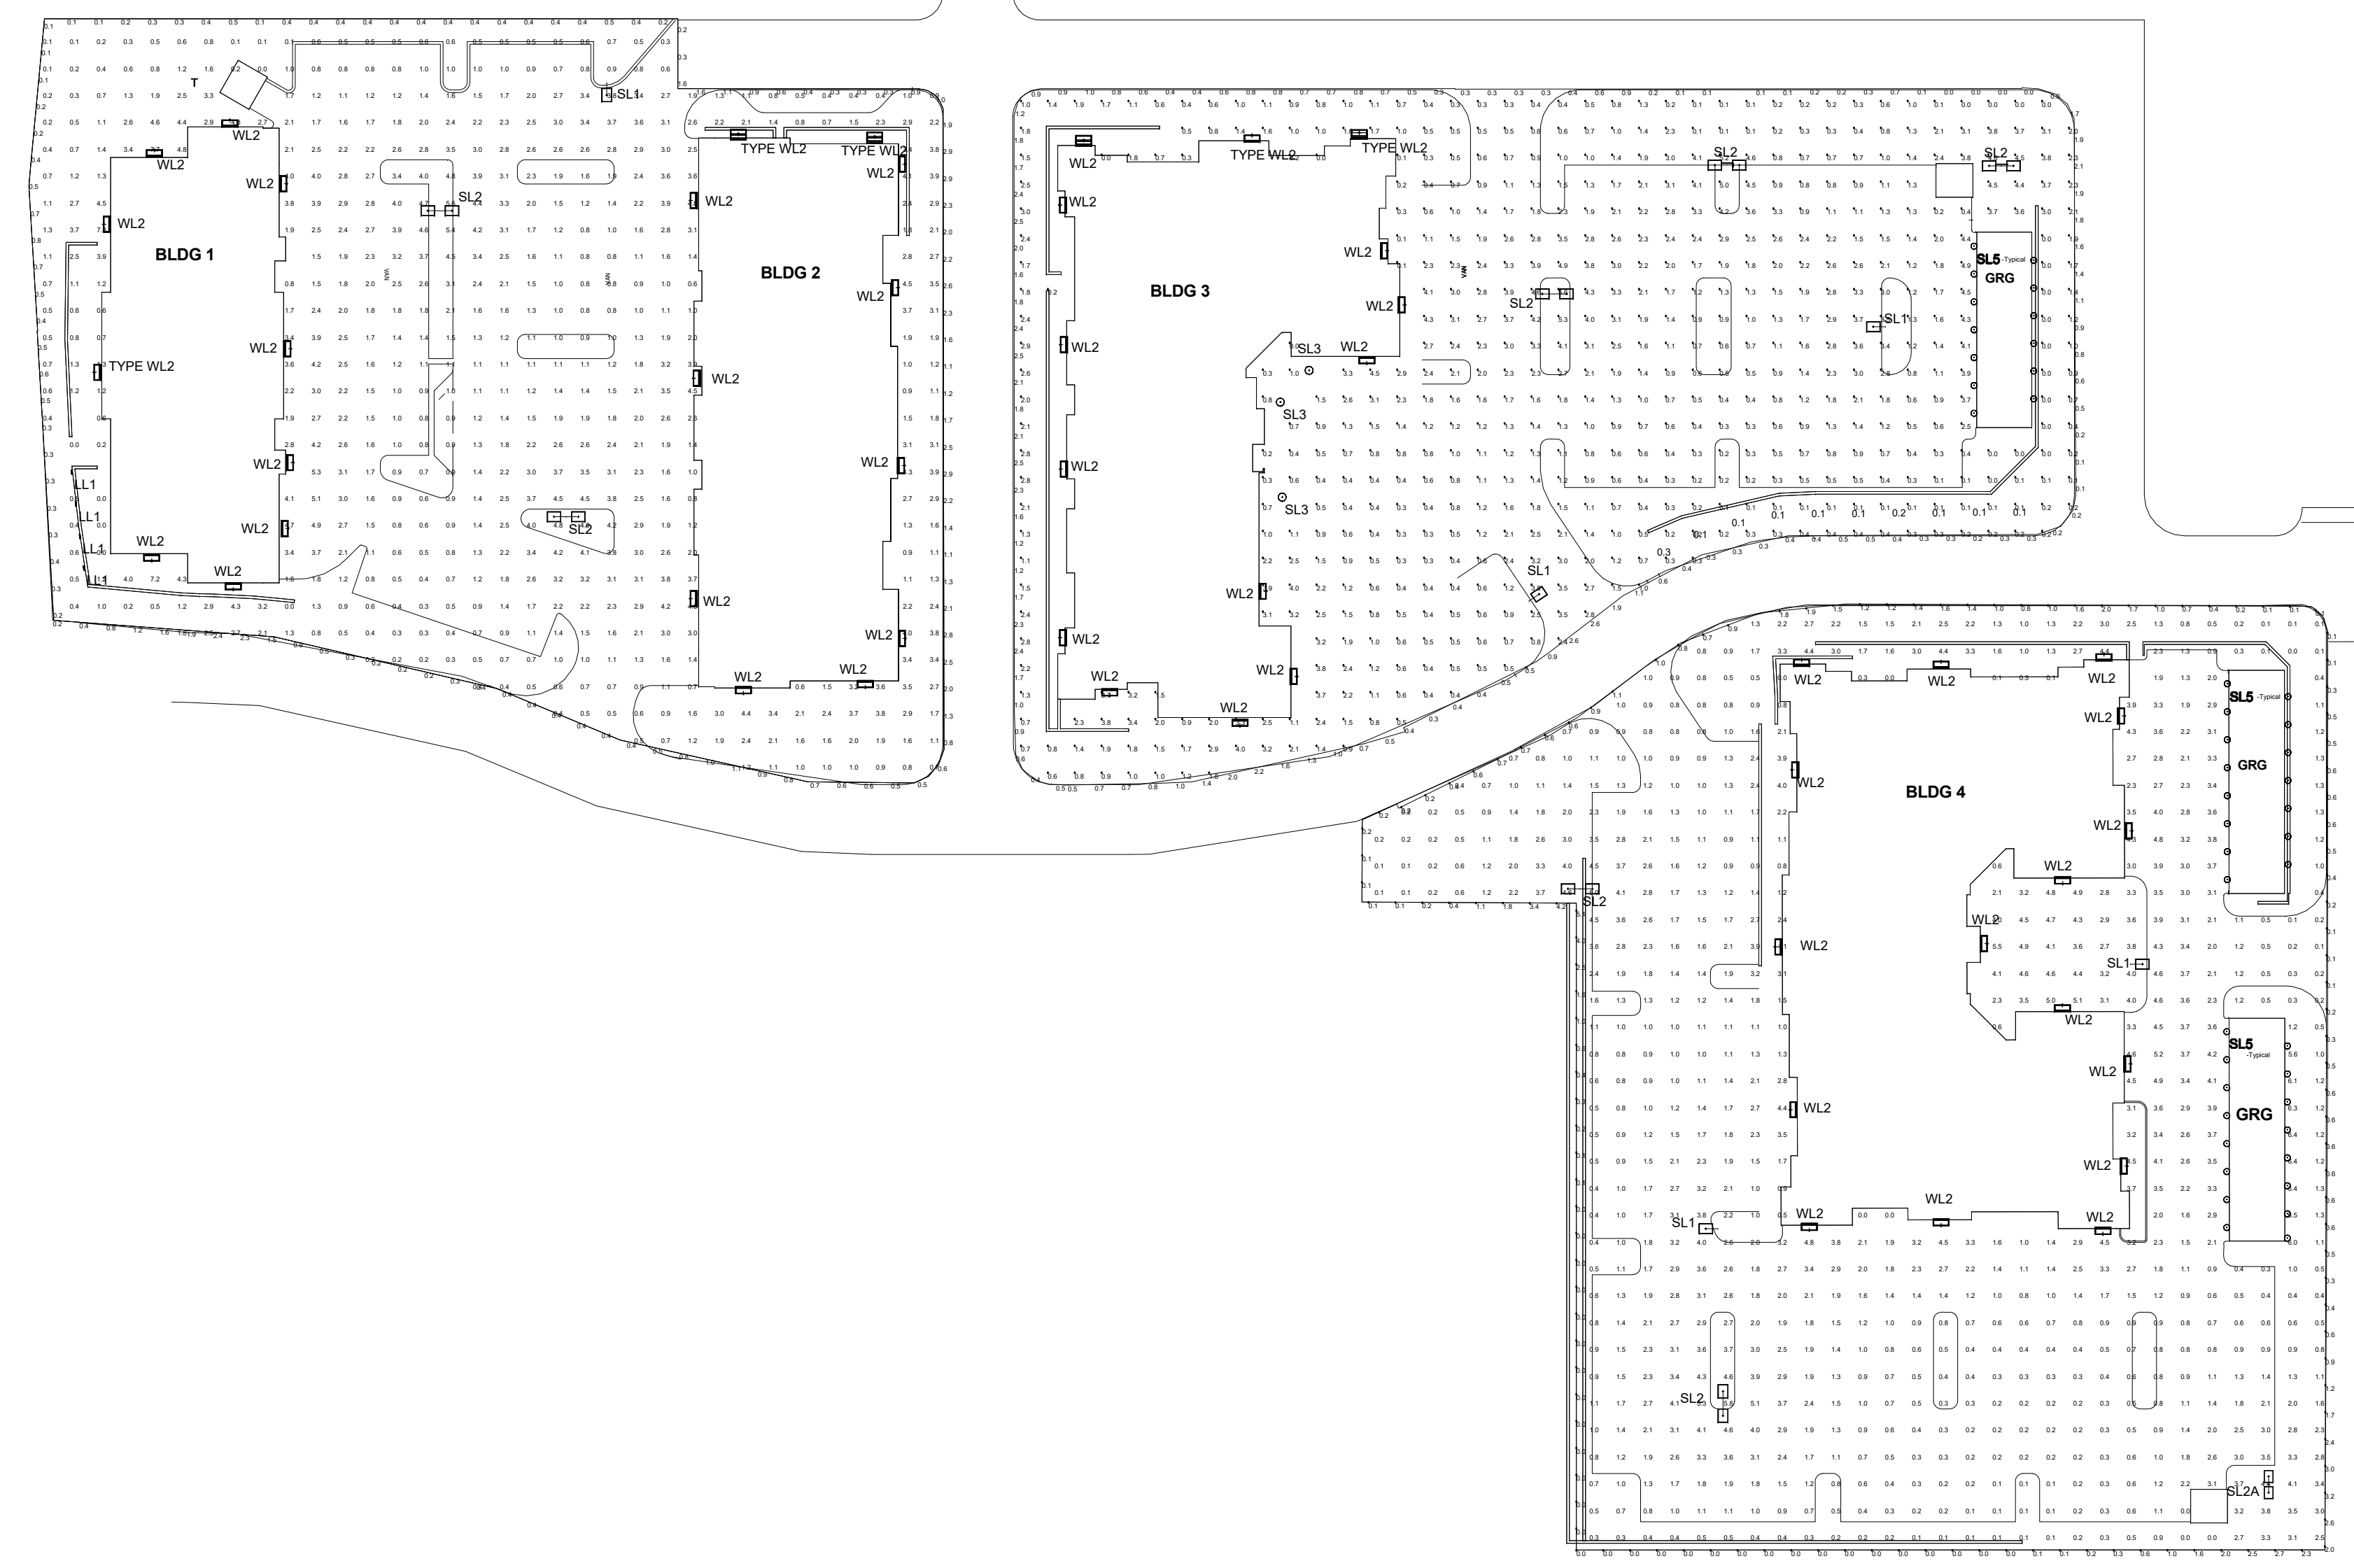

SITE ILLUMINANCE		
MINIMUM	MAXIMUM	AVERAGE
0.1	7.8	1.73
SITE UNIFORMITY RATIOS		
RESIDENTIAL AREA	AVG:MIN	MAX:MIN
DRIVEWAYS	4:01	11:01
WALKWAYS	2:01	3:01
PARKING	5:01	6:01

FOR REVIEW ONLY
 NOT FOR
 CONSTRUCTION



#	Date	Comments
	04/19/2021	Lighting Responses to Staff Comments 03

Drawn By:	Checked By:	Date:	Scale:
j.rago	j.rago	04/19/2021	1in = 60ft

PARKER AND PINE FILING NO.2
 LOTS 1-3 PARKER, CO
 SITE LIGHTING CALCS

