

LOT 6 - PARKER AND PINE FILING 1.
SITUATED IN THE SE 1/4 OF SECTION 9 AND THE SW 1/4
OF SECTION 10, T.6S., R.66W. OF THE 6TH P.M.
TOWN OF PARKER, COUNTY OF DOUGLAS,
STATE OF COLORADO

DEVELOPER:
NLD PARKER, LLC.
C/O CAPITAL REAL ESTATE, INC.
60 SOUTH 6TH STREET, SUITE 2630
MINNEAPOLIS, MN 55402
TEL: (612) 313-0126
CONTACT: ALLISON MORGAN

ENGINEER
KIMLEY-HORN AND ASSOCIATES, INC.
4582 SOUTH ULSTER STREET, SUITE 1500
DENVER, CO 80237
TEL: (303) 228-2318
CONTACT: DAN SKEEHAN

LANDSCAPE ARCHITECT
KIMLEY-HORN AND ASSOCIATES, INC.
4582 SOUTH ULSTER STREET, SUITE 1500
DENVER, CO 80237
TEL: (303) 228-2300
CONTACT: CHRIS HEPLER

TELEPHONE
CENTURYLINK
1801 CALIFORNIA STREET, SUITE 240
DENVER, CO 80202
CONTACT: IZZY MILLER
EMAIL: IZZY.MILLER@CENTURYLINK.COM

GAS SERVICE
XCEL ENERGY
1800 LARIMER STREET
DENVER, CO 80202
CONTACT: RON JOHNSON
EMAIL: RON.H.JOHNSON@XCELENERGY.COM

ARCHITECT:
ADA ARCHITECTS, INC.
17710 DETROIT AVE
CLEVELAND, OH 44107
TEL: (216) 521-5134
CONTACT: JAVIER CORA

SURVEYOR
ENGINEERING SERVICE COMPANY
1300 SOUTH POTOMAC ST. SUITE 126
AURORA, CO 80012
TEL: (303) 337-1393

TELEVISION
COMCAST
1601 MILE HIGH STADIUM CIRCLE
DENVER, CO 80204
CONTACT: DEAN FLENTHROPE
EMAIL: DEAN_FLENTHROPE@CABLE.COMCAST.COM

 
WATER/SANITARY SEWER
PARKER WATER AND SANITATION DISTRICT
18100 E. WOODMAN ROAD
PARKER, CO 80134
TEL: (303) 841-4627
CONTACT: DRAYTON SANDERSON

ELECTRICAL SERVICE
IREA
5496 US HWY 85
SEDALIA, CO 80135
TEL: (303) 688-7431
CONTACT: AMANDA STEINER

TOWN OF PARKER
TOWN OF PARKER
20120 EAST MAINSTREET
PARKER, CO 80138-7334
TEL: (303) 805-3199
CONTACT: STACEY NERGER

FIRE DEPARTMENT
TOWN OF PARKER
20120 E. MAIN STREET
PARKER, CO 80138
TEL: (303) 805-3169
CONTACT: RANDY CAPRA

TOWN OF PARKER PLAN REVIEW
20120 E. MAINSTREET
PARKER, CO 80138
TEL: (303) 805-3174
CONTACT: BRYCE MATTHEWS



DISTRICT ACCEPTANCE NOTE

1. UPON COMPLETION OF SANITARY AND WATER CONSTRUCTION AND TESTING, THE DEVELOPER OR CONTRACTOR SHALL CONTACT THE DISTRICT FOR PROBATIONARY ACCEPTANCE INSPECTION. A PUNCHLIST WILL BE PROVIDED FOR THE DEVELOPER AND CONTRACTOR UPON COMPLETION OF THE INITIAL WALK-THRU AND PROBATIONARY ACCEPTANCE WILL BE ISSUED FOLLOWING COMPLETION AND ACCEPTANCE OF THE WORK OUTLINED IN THE PUNCHLIST.
2. THE CONTRACTOR WILL BE HELD RESPONSIBLE FOR THE PROPER FUNCTIONING OF THE LINES FOR UP TO TWO (2) YEARS FROM THE DATE OF PROBATIONARY ACCEPTANCE OF THE LINES BY THE DISTRICT. ANY MALFUNCTION DURING THIS PERIOD OF GUARANTEE SHALL BE REMEDIED BY THE CONTRACTOR TO THE SATISFACTION OF THE DISTRICT ENGINEER AT NO EXPENSE TO THE DISTRICT.
3. THE DATE OF FINAL ACCEPTANCE WILL BE INDICATED IN THE CONDITION OF THE PROBATIONARY ACCEPTANCE LETTER. THE DEVELOPER SHALL BE RESPONSIBLE FOR CONTACTING THE DISTRICT FOR FINAL INSPECTION AND FINAL ACCEPTANCE.

BY SCALED MAP LOCATION AND GRAPHIC PLOTTING ONLY, THIS
PROPERTY LIES IN ZONE X OF THE FLOOD INSURANCE RATE MAP,
COMMUNITY PANEL NUMBER 08035C0067G AND DATED MARCH 16,
2016 - SUBJECT PROPERTY IS NOT IN A SPECIAL FLOOD HAZARD
AREA.

LOT 6, PARKER AND PINE FILING 1, SITUATED IN THE SOUTHEAST
1/4 OF SECTION 9 AND THE SOUTHWEST 1/4 OF SECTION 10,
TOWNSHIP 6 SOUTH, RANGE 66 WEST OF THE 6TH PRINCIPAL
MERIDIAN, COUNTY OF DOUGLAS, STATE OF COLORADO.

DOUGLAS CONTROL MONUMENT #1.095035, A 3 1/4" ALUMINUM CAP.

ELEVATION = 5906.34 FEET (NAVD 1988), AS PUBLISHED BY DOUGLAS COUNTY.

BEARINGS SHOWN HEREON ARE BASED UPON THE WEST LINE OF THE SW 1/4 OF SECTION 10, TOWNSHIP 6 SOUTH, RANGE 66 WEST, OF THE 6TH PRINCIPAL MERIDIAN BEARING N00°17'51"E AS REFERENCED ON THE PLAT OF PARKER AUTO PLAZA FILING NO. 1 AND BOUND BY THE MONUMENTS SHOWN HEREON.

DESCRIPTION	QTY.	UNIT
6" PVC SANITARY SERVICE	112	LF
1.5" TYPE K COPPER SERVICE	74	LF
6" DIP FIRE LINE	74	LF

*QUANTITIES ARE FOR REFERENCE ONLY.
CONTRACTOR SHALL VERIFY ALL
QUANTITIES PRIOR TO CONSTRUCTION

FIRE CODE REVIEW BLOCK

ALL FIRE HYDRANTS SHALL BE INSTALLED ACCORDING TO WATER UTILITY STANDARDS. THE NUMBER AND LOCATIONS OF THE FIRE HYDRANTS AS SHOWN ON THE OVERALL UTILITY PLAN ARE CORRECT AS SPECIFIED BY THE TOWN OF PARKER, COMMUNITY DEVELOPMENT DEPARTMENT.

FIRE CODE OFFICIAL OR DESIGNATED REPRESENTATIVE	DATE
(NOTE - UNDERGROUND FIRE LINE (UFL) SUBMITTAL DOCUMENTS MUST MEET THE REQUIREMENTS OF NFPA 24 WHEN SUBMITTING FOR REVIEW)	

[illegible]

Kimley»»Horn
2021 KIMLEY-HORN AND ASSOCIATES, INC.
4582 South South Ulster Street, Suite 1500

DESIGNED BY: MCN
DRAWN BY: NMH
CHECKED BY: DLS
DATE: 05/07/2021


LOT 6 PARKER AND PINE FILING 1
PARKER, CO
EVERBROOK ACADEMY CONSTRUCTION DOCUMENTS
COVER SHEET




PROJECT NO.
096895001

DRAWING NAME
096895001UT CV

C7.0


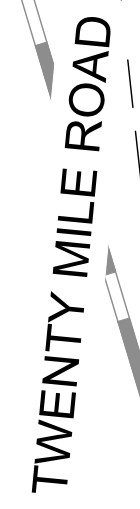


UTILITY LEGEND

 - | | |
|---|-----------------------------------|
|  | EXISTING PROPERTY LINE |
|  | EXISTING EASEMENT |
|  | PROPOSED EASEMENT |
|  | PROPOSED SANITARY SEWER LINE |
|  | PROPOSED WATER LINE |
|  | PROPOSED STORM DRAINAGE LINE |
|  | EXISTING STORM DRAINAGE LINE |
|  | EXISTING GAS LINE |
|  | EXISTING WATER LINE |
|  | EXISTING SANITARY SEWER LINE |
|  | EXISTING ELECTRIC LINE |
|  | PROPOSED FIRE HYDRANT W/ BOLLARDS |
|  | PROPOSED WATER VALVE |
|  | PROPOSED TEE / BEND |
|  | EXISTING SANITARY SEWER MANHOLE |
|  | FDC |

SITE KEYNOTES

- ① EXISTING FIRE HYDRANT
- ② CONNECT DOMESTIC WATER TO EXISTING 8" WATER MAIN
- ③ EXISTING 6" STUB W/TEMP BLOW-OFF
- ④ EXISTING 8" WATER MAIN
- ⑤ EXISTING 8" SEWER MAIN
- ⑥ EXISTING 6" SEWER STUB
- ⑦ EXISTING 8" EFFLUENT FORCE MAIN
- ⑧ EXISTING 20" DIP WATER MAIN
- ⑨ EXISTING 27" ACP SANITARY SEWER MAIN
- ⑩ PROPOSED 6" PVC SANITARY SEWER LINE
- ⑪ PROPOSED 6" DIP FIRE LINE
- ⑫ PROPOSED 1.5" PVC DOMESTIC WATER SERVICE
- ⑬ PROPOSED 8" C900 PVC EFFLUENT FORCE MAIN UNDER SEPARATE PERMIT
- ⑭ PROPOSED 6" DIP 45 DEGREE BEND WITH HORIZONTAL THRUST BLOCK
- ⑮ CONNECT TO EXISTING 8" PVC FORCE MAIN WITH 8" DIP 45 DEGREE BEND WITH HORIZONTAL THRUST BLOCK UNDER SEPARATE PERMIT
- ⑯ CONNECT TO EXISTING SANITARY SEWER STUB/CLEANOUT.
- ⑰ CONNECT TO EXISTING WATER STUB
- ⑱ PROPOSED 6" SANITARY SEWER BUILDING POINT OF CONNECTION.
- ⑲ PROPOSED 1.5" DOMESTIC WATER SERVICE BUILDING POINT OF CONNECTION.
- ⑳ PROPOSED 6" FIRE SERVICE BUILDING POINT OF CONNECTION.
- ㉑ PROPOSED SANITARY SEWER CLEANOUT.
- ㉒ PROPOSED CONCRETE CASING. SEE SHEET C7.6 FOR DETAIL.
- ㉓ PROPOSED FIRE DEPARTMENT CONNECTION

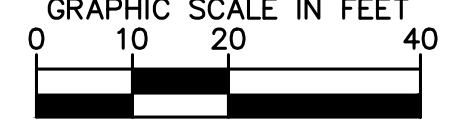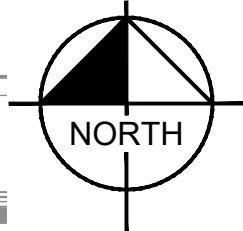

THE TOWN OF PARKER REVIEW CONSTITUTES GENERAL COMPLIANCE WITH THE TOWN'S STANDARDS AND APPROVED VARIANCES, SUBJECT TO THESE PLANS BEING STAMPED, SIGNED, AND DATED BY THE PROFESSIONAL ENGINEER OF RECORD. REVIEW BY THE TOWN DOES NOT CONSTITUTE APPROVAL OF THE PLAN DESIGN OR ACCURACY AND CORRECTNESS OF ENGINEERING CALCULATIONS. ERRORS IN THE DESIGN OR CALCULATIONS REMAIN THE RESPONSIBILITY OF REGISTERED PROFESSIONAL ENGINEER WHOSE STAMP AND SIGNATURE ARE AFFIXED TO THIS DOCUMENT.

THIS REVIEW DOES NOT CONSTITUTE APPROVAL OF ANY PRIVATE ON-SITE IMPROVEMENTS WHICH MAY BE SHOWN. CONSTRUCTION CANNOT COMMENCE UNTIL ALL REQUIRED DRAINAGE/TRAFFIC REPORT(S), FINAL DEVELOPMENT PLAN(S), SPECIAL REVIEW(S), GRADING PERMIT, AND/OR OTHER PERMITS ARE COMPLETE, APPROVED AND ON FILE WITH THE TOWN OF PARKER.

TOWN OF PARKER, DIRECTOR OF ENGINEERING _____ DATE _____

FIRE CODE REVIEW BLOCK

ALL FIRE HYDRANTS SHALL BE INSTALLED ACCORDING TO WATER UTILITY STANDARDS. THE NUMBER AND LOCATIONS OF THE FIRE HYDRANTS AS SHOWN ON THE OVERALL UTILITY PLAN ARE CORRECT AS SPECIFIED BY THE TOWN OF PARKER, COMMUNITY DEVELOPMENT DEPARTMENT.

FIRE CODE OFFICIAL OR DESIGNATED REPRESENTATIVE	DATE
---	------







(NOTE – UNDERGROUND FIRE LINE (UFL) SUBMITTAL DOCUMENTS MUST MEET THE REQUIREMENTS OF NFPA 24 WHEN SUBMITTING FOR REVIEW)



Know what's **below**.
Call before you dig.

[illegible]

K:\DEV_Civil\096895001 - Lot 6 Parker & Pine\CAD\Plumbing\096895001UT_SSWR.dwg Newsthor, M.D.
THIS DOCUMENT CONTAINS UNCLASSIFIED INFORMATION. IT IS THE PROPERTY OF KIMLEY-HORN AND ASSOCIATES, INC. AND IS NOT TO BE REPRODUCED OR TRANSMITTED IN ANY FORM OR BY ANY MEANS, ELECTRONIC OR MECHANICAL, INCLUDING PHOTOCOPYING, RECORDING, OR BY ANY INFORMATION STORAGE AND RETRIEVAL SYSTEM, WITHOUT PERMISSION IN WRITING FROM KIMLEY-HORN AND ASSOCIATES, INC.

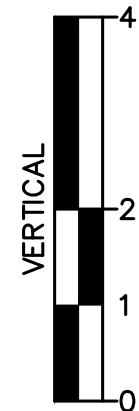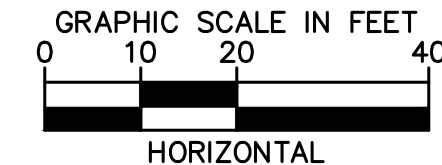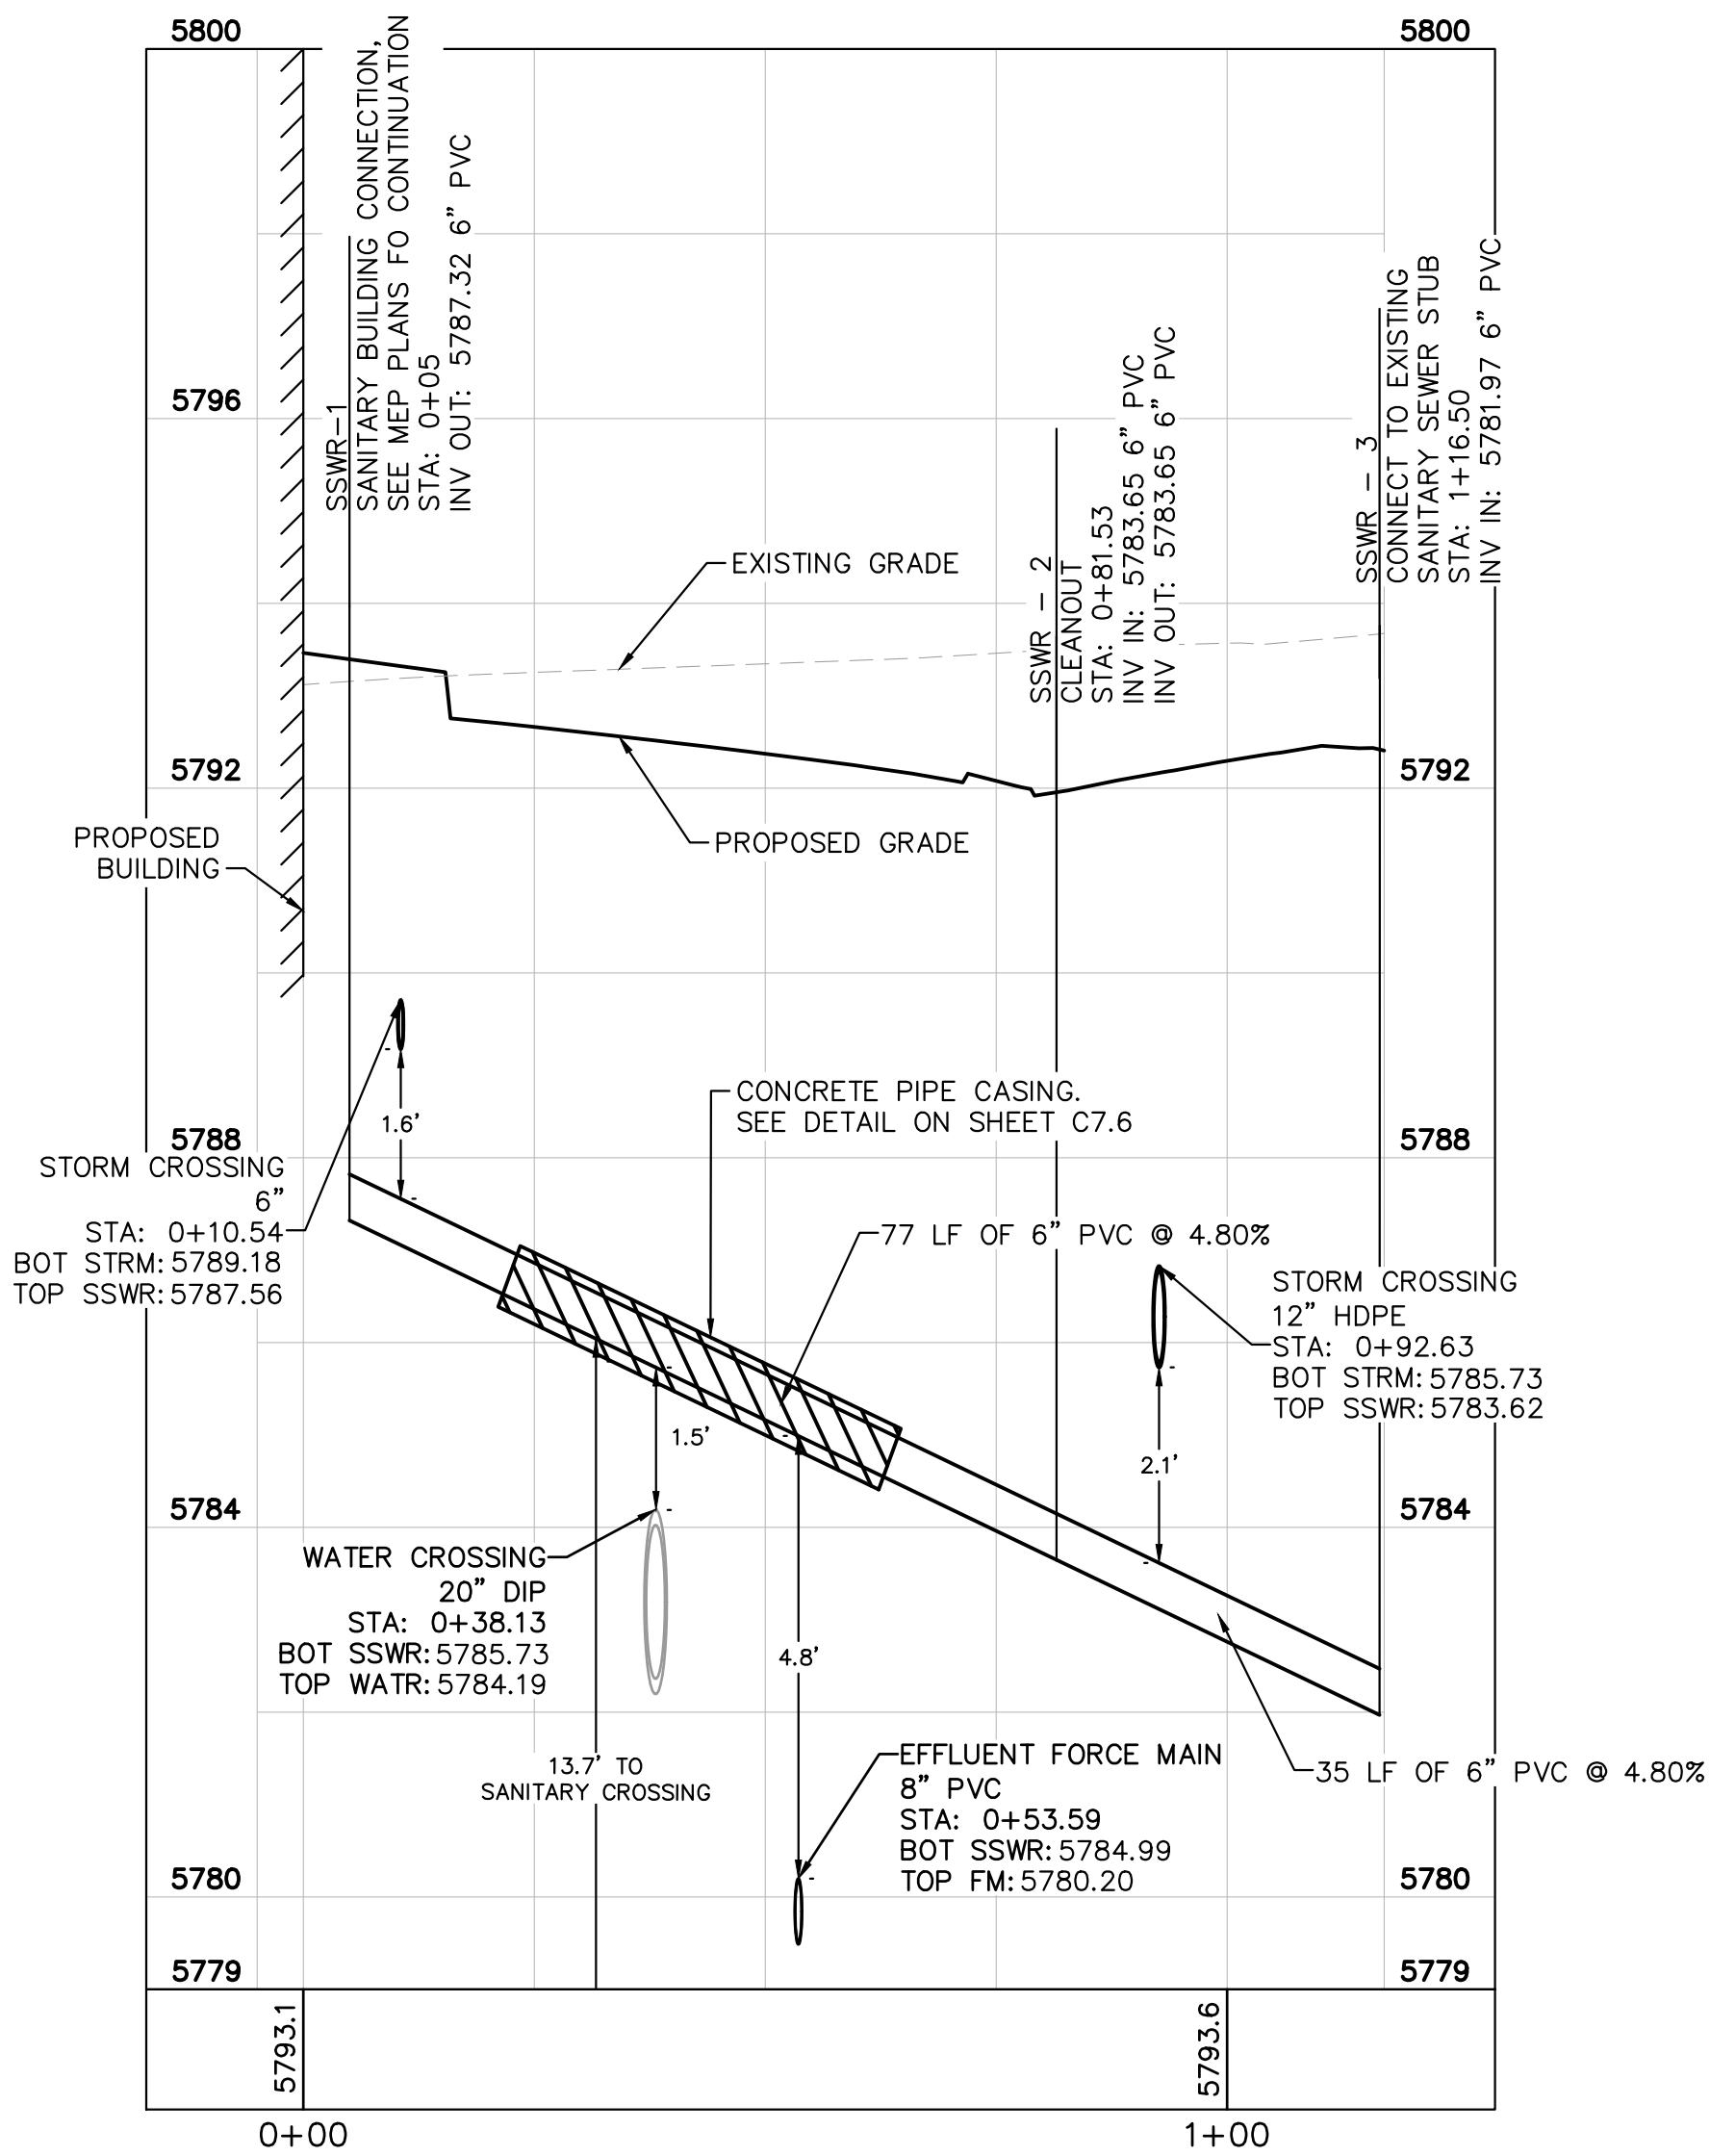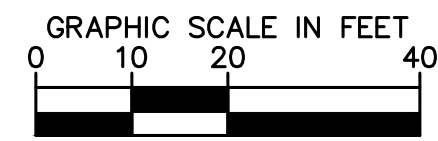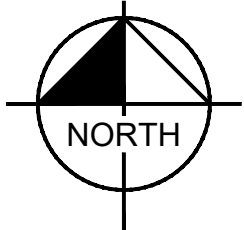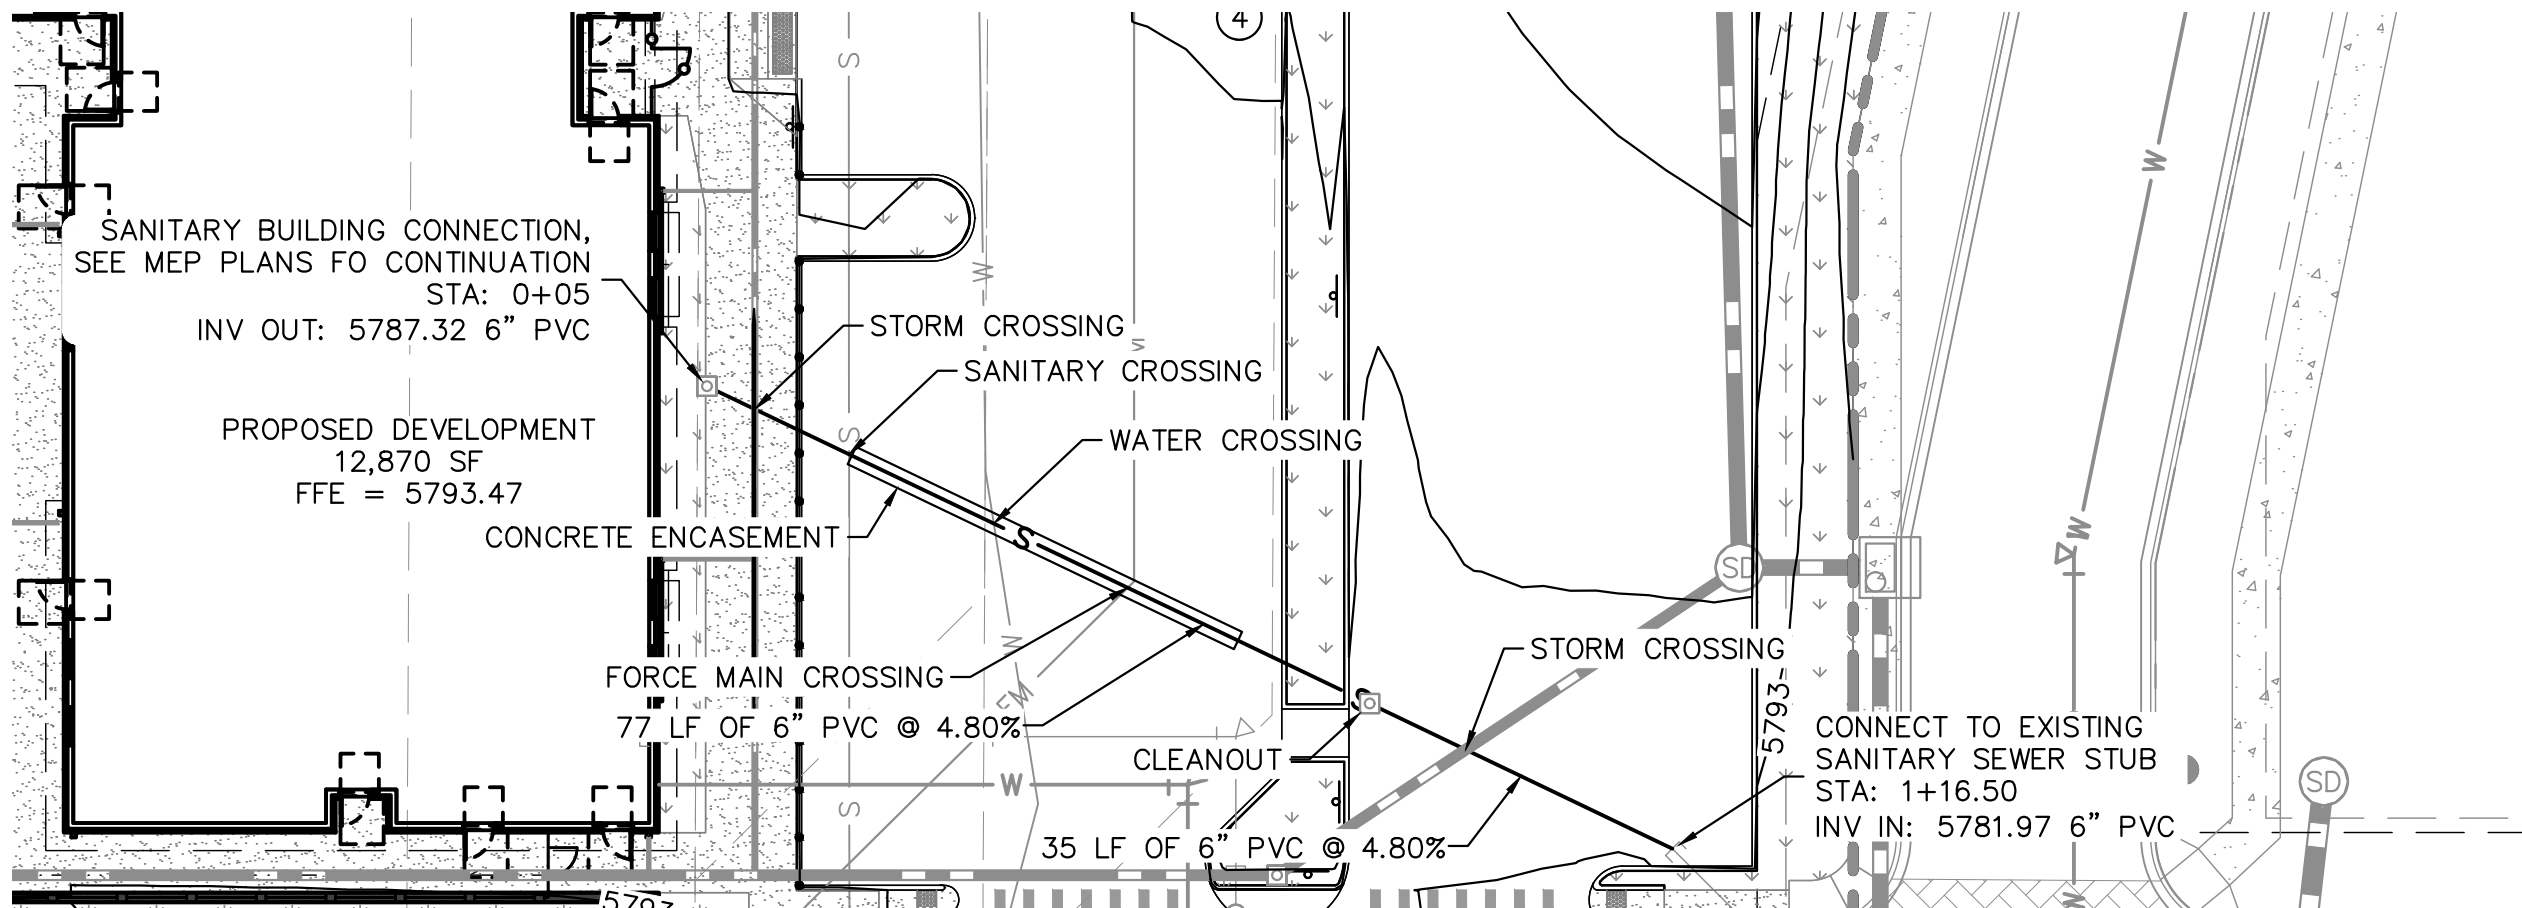

Know what's below.
Call before you dig.

UTILITY LEGEND

- EXISTING PROPERTY LINE
- EXISTING EASEMENT
- PROPOSED EASEMENT
- FM --- PROPOSED SANITARY SEWER FORCE MAIN
- EXISTING STORM DRAINAGE LINE
- G --- EXISTING GAS LINE
- W --- EXISTING WATER LINE
- S --- EXISTING SANITARY SEWER LINE
- E --- EXISTING ELECTRIC LINE
- O --- EXISTING SANITARY SEWER MANHOLE

NOTES:

- CONTRACTOR TO FIELD VERIFY SIZE, INVERT, AND LOCATION OF ALL EXISTING UTILITIES.

Kimley»Horn

2021 KIMLEY-HORN AND ASSOCIATES, INC.
4582 South Ulster Street, Suite 1500
Denver, Colorado 80237 (303) 228-2300

DESIGNED BY: MCN
DRAWN BY: NMH
CHECKED BY: DLS
DATE: 05/07/2021

LOT 6 PARKER AND PINE FILING 1
PARKER, CO
EVERBROOK ACADEMY CONSTRUCTION DOCUMENTS
SANITARY SEWER LINE PLAN AND PROFILE







PROJECT NO.
096895001

DRAWING NAME
096895001UT_SSWR

C7.3

K:\DEV_Civil\096895001 - Lot 6 Parker & Pine\CAD\Drawings\096895001UT_WATR.dwg Newsticker: MCA
THIS DOCUMENT CONTAINS THE CONCEPTS AND DESIGNS PRESENTED HEREIN, AS AN INSTRUMENT OF SERVICE, IS INTENDED ONLY FOR THE SPECIFIC PROJECT AND CLIENT FOR WHICH IT WAS PREPARED. REUSE OF AND IMPROPER RELIANCE ON THIS DOCUMENT WITHOUT WRITTEN AUTHORIZATION AND ADAPTATION BY KIMLEY-HORN AND ASSOCIATES, INC. SHALL BE WITHOUT LIABILITY TO KIMLEY-HORN AND ASSOCIATES, INC.

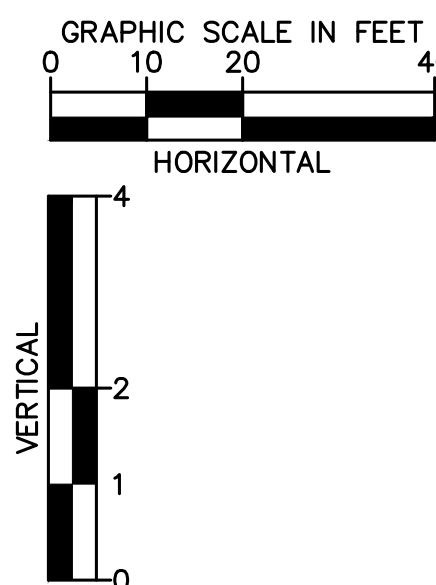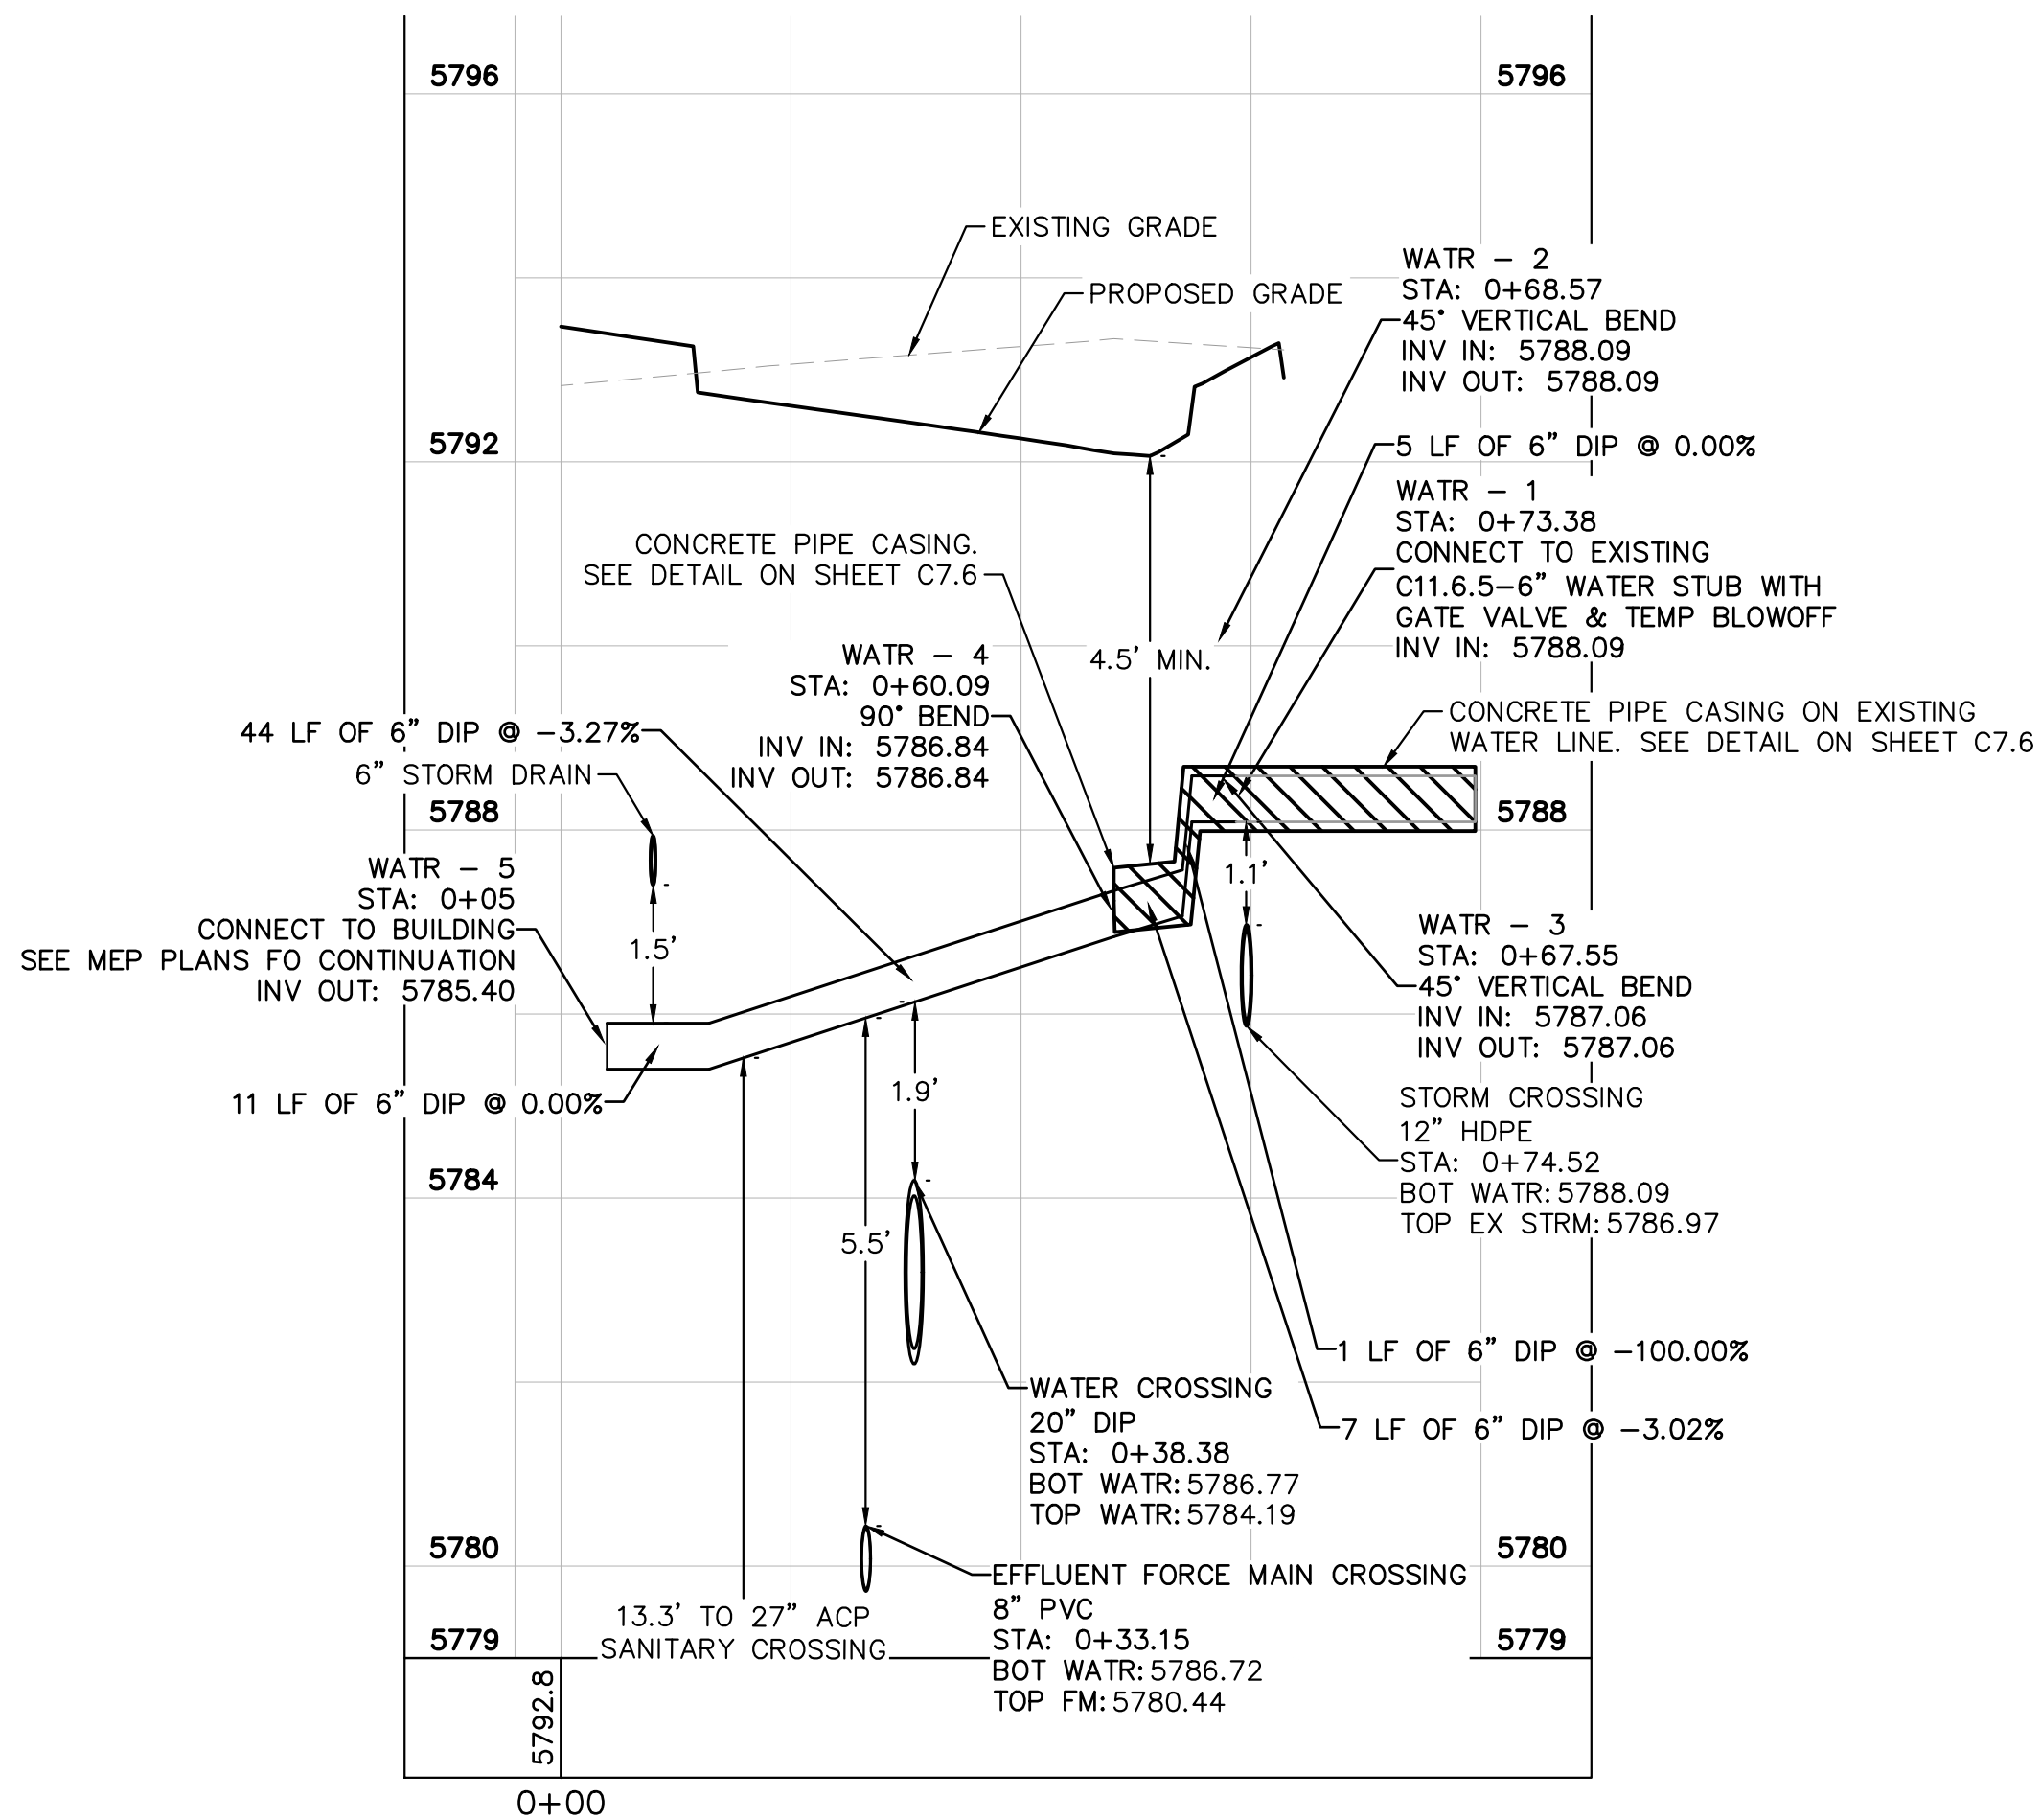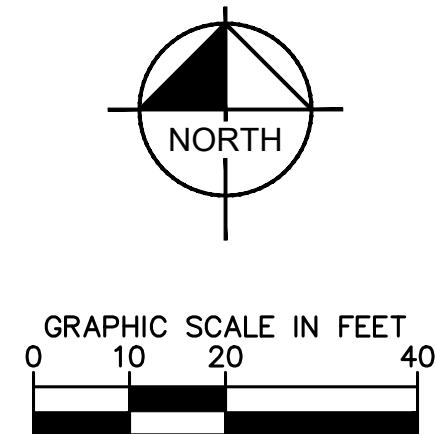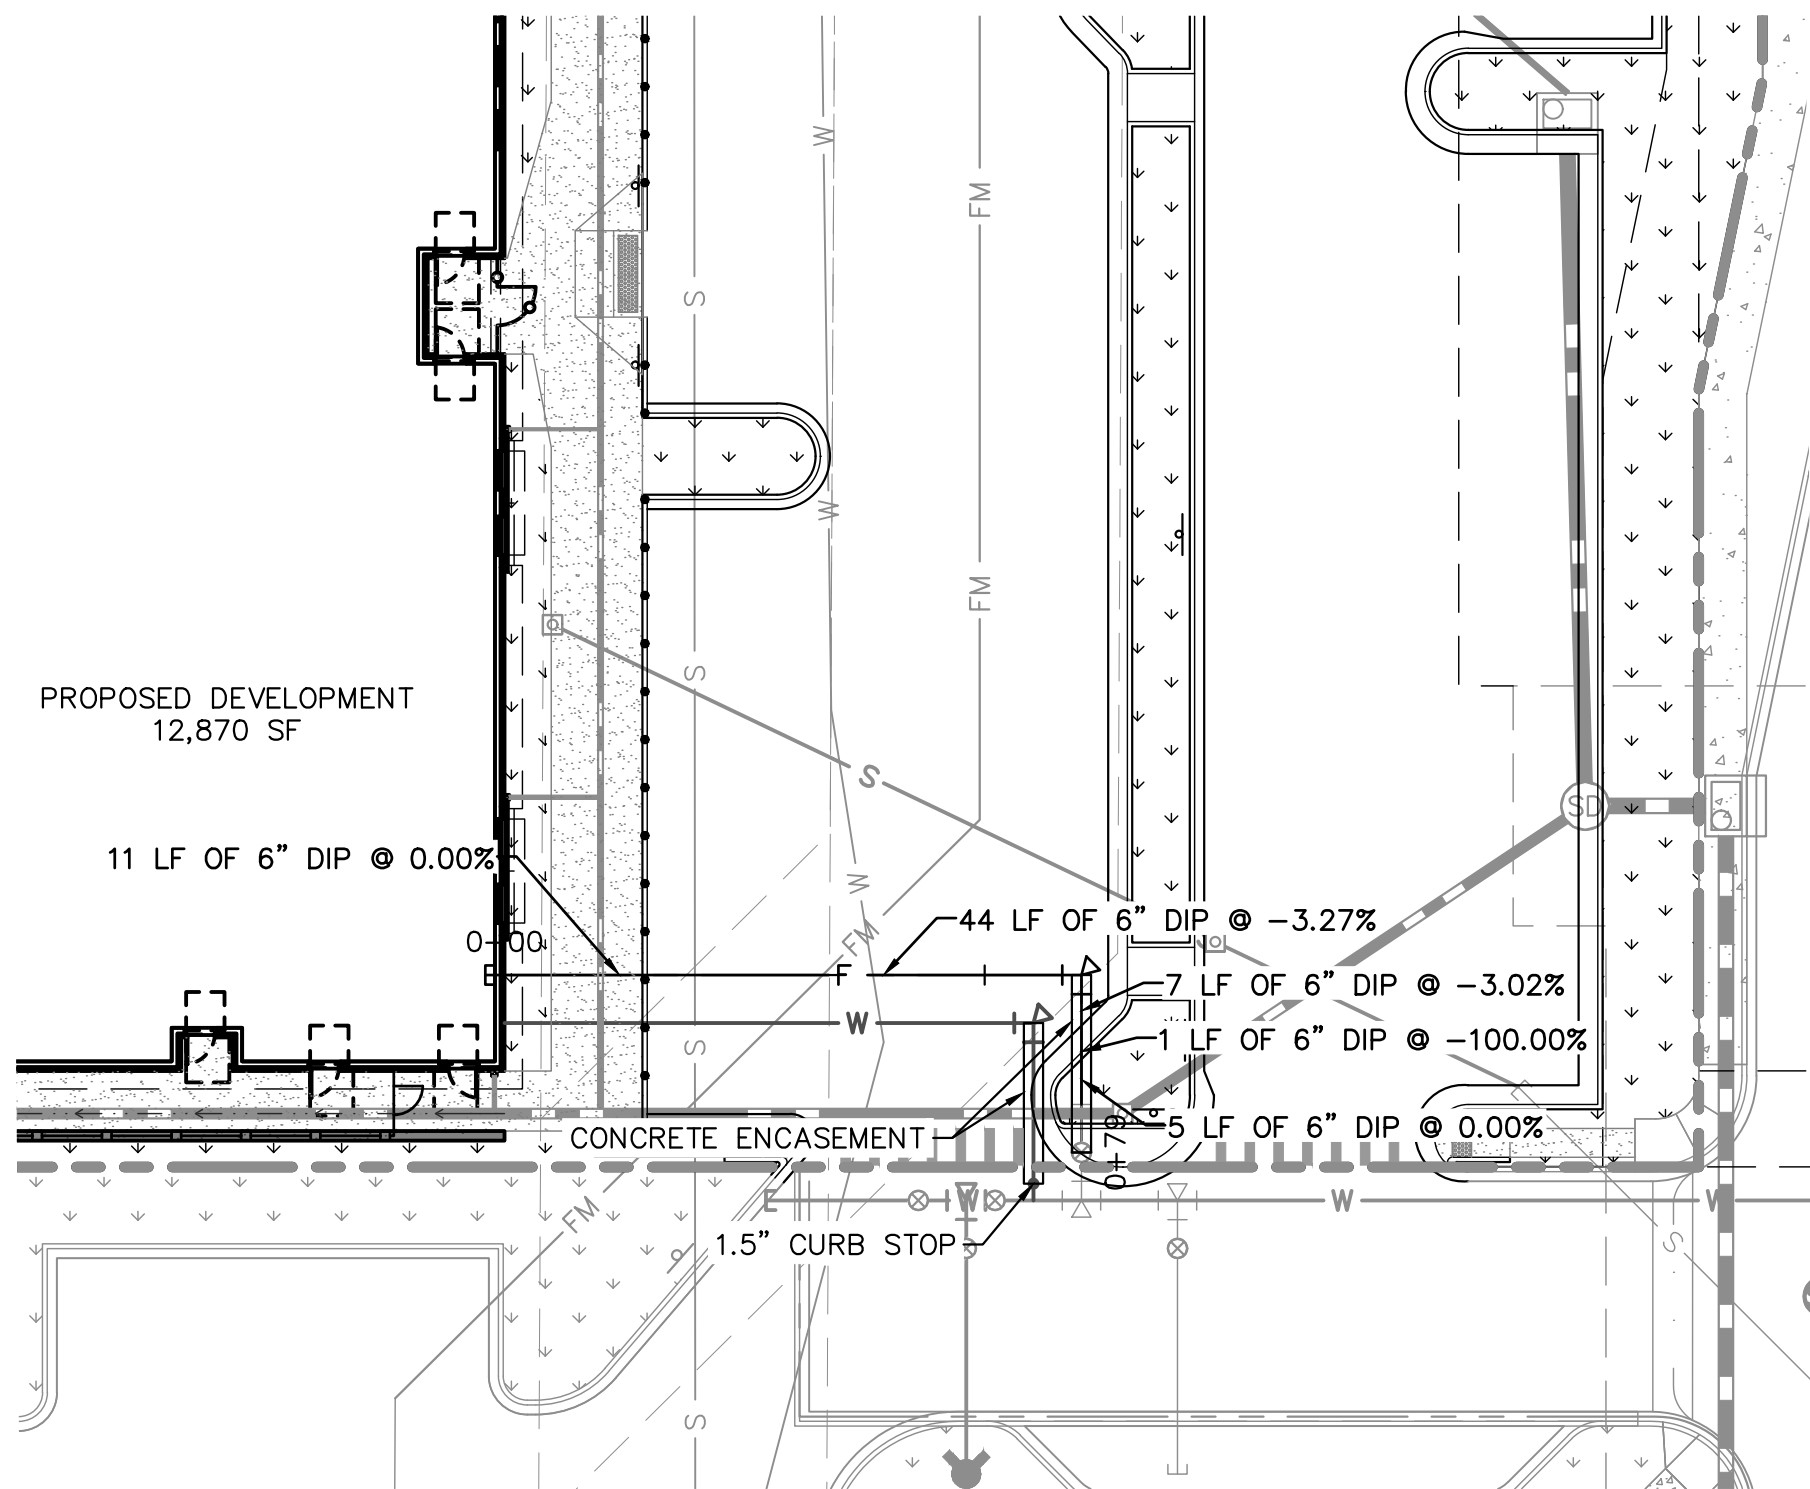

LEGEND:

---	PROPERTY LINE
---	EXISTING WATER LINE
---	PROPOSED WATER LINE
---	EXISTING SANITARY SEWER LINE
---	PROPOSED SANITARY SEWER LINE
---	PROPOSED STORM LINE
---	PROPOSED FIRE LINE
---	PROPOSED FORCE MAIN

WATER NOTES


1. CONTRACTOR TO POTHOLE EXISTING UTILITY LINES AT WATER LINE CROSSING AREAS PRIOR TO CONSTRUCTION.
2. WATER LINE CONNECTION ELEVATION TO EXISTING WATER MAINS IS APPROXIMATE. CONTRACTOR TO POTHOLE AND VERIFY TIE IN ELEVATION PRIOR TO CONSTRUCTION OF WATER MAIN.
3. CONTRACTOR TO MEET THE INSTALLATION REQUIREMENTS BY THE PARKER WATER AND SANITATION DISTRICT DESIGN STANDARDS AND CONSTRUCTION SPECIFICATIONS.
4. VERTICAL BENDS AND DEFLECTIONS MAYBE UTILIZED TO PROVIDE VERTICAL CHANGES IN ACCORDANCE WITH PWSD STANDARDS AS NEEDED.
5. ALL WATER LINES SHALL BE INSTALLED AT LEAST 4.5 FEET BELOW THE SURFACE OF THE GROUND.

Kimley»Horn

2021 KIMLEY-HORN AND ASSOCIATES, INC.
4582 South Ulster Street, Suite 1500
Denver, Colorado 80237 (303) 228-2300

DESIGNED BY: MCN
DRAWN BY: NMH
CHECKED BY: DLS
DATE: 05/07/2021

LOT 6 PARKER AND PINE FILING 1
PARKER, CO
EVERBROOK ACADEMY CONSTRUCTION DOCUMENTS
WATER LINE PLAN AND PROFILE

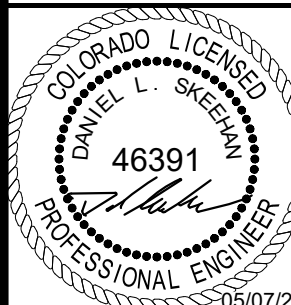

PROJECT NO.
096895001

DRAWING NAME
096895001UT_WATR

C7.4

- [illegible]

2016 REVISION

SHEET S4.8



NTS

- NOTES:
1. ALL CONCRETE SHALL HAVE A 28 DAY STRENGTH OF 3,000 PSI USING TYPE I PORTLAND CEMENT AND 3/4" AGGREGATE. ALL CONCRETE SHALL HAVE 5-7% ENTRAINED AIR CONTENT AND A MAXIMUM SLUMP OF 4".
 2. ALL REINFORCEMENT SHALL CONFORM TO ASTM A615, GRADE 60.
 3. ALL REINFORCEMENT SHALL HAVE 2" MIN. CONCRETE COVER.
 4. THE SUBGRADE SHALL BE COMPACTED TO 95% OF THE MAXIMUM STANDARD PROCTOR DENSITY PRIOR TO FORMING THE STRUCTURE.

2016 REVISION

SHEET W4.3

Kimley»»Horn

2021 KIMLEY-HORN AND ASSOCIATES, INC.
4582 South South Ulster Street, Suite 1500
Denver, Colorado 80237 (303) 228-2300

DESIGNED BY: MCN
DRAWN BY: NMH
CHECKED BY: DLS
DATE: 05/07/2021

LOT 6 PARKER AND PINE FILING 1
PARKER, CO
EVERBROOK ACADEMY CONSTRUCTION DOCUMENTS
WATER & SANITARY SEWER DETAILS



PROJECT NO
096895001

DRAWING NAME
096895001UT DTL

C7.6



Know what's **below**.
Call before you dig.